

SECTION
A300 SCALE: 1/2"=1'-0"



7612 Browns Bridge Road
Highland, MD 20777
301-776-2666
info@TransformingArchitecture.com
www.TransformingArchitecture.com



I CERTIFY THAT THESE DOCUMENTS WERE PREPARED OR APPROVED BY ME, AND THAT I AM A DULY LICENSED ARCHITECT UNDER THE LAWS OF THE STATE OF MARYLAND, LICENSE NUMBER 13662, EXPIRATION 10-22-2021.

NOTE: THESE DRAWINGS ARE THE PROPERTY OF TRANSFORMING ARCHITECTURE AND, AS SUCH, MAY NOT BE RE-USED OR REPRODUCED, EITHER WHOLLY OR IN PART, WITHOUT PRIOR WRITTEN CONSENT OF TRANSFORMING ARCHITECTURE.

PROJECT PHASE
PERMIT

 


PROJECT TITLE
THE WIZZARD RESIDENCE
1608 Florence Road
MT AIRY, MD 21771

REVISIONS		
SYMBOL	DATE	ISSUED FOR
▲	09/14/2021	BUILDING PLAN REVIEW


 






 
 

 

 
PROJECT NUMBER 21-594
DATE 07/16/2021
SCALE AS NOTED

DRAWING TITLE
SECTION

SHEET NUMBER
A-300

LINE TYPE KEY:
 NEW WALL 
 ABOVE LINE 
 FDN. WALL 

ELECTRICAL LEGEND


-  SWITCH
-  OUTLET
-  GFI OUTLET
-  RECESSED LED CLG. LIGHT
-  LED WALL MOUNT FIXTURE
-  LED CLG. FIXTURE
-  EXHAUST FAN WITH HUMIDISTAT
-  CLG. FAN W/ LIGHT
-  CABLE TV
-  HARDWIRED SMOKE DETECTOR W/ INTERNAL BATTERY & CARBON MONOXIDE DETECTOR (COMBINED UNIT)
-  SPEAKER
-  HOME RUN ALL SPEAKER WIRES TO THIS LOCATION
-  2-HEAD FLOOD
-  HOSE BIB

ELECTRICAL NOTES:

1. OUTLETS PER CODE @ 18" H, 42" H ABOVE COUNTERTOPS UNLESS OTHERWISE NOTED.
2. MOUNT LIGHT SWITCHES @ 42" H. MAX. ROCKER-TYPE
3. PROVIDE HARD-WIRED SMOKE DETECTORS PER CODE
4. QUIET CLG. FANS W/ LIGHT FIXTURES
5. PROVIDE UNDER-CABINET LIGHTING
6. HINGE SWITCHES IN ALL CLOSETS U.N.O
7. ALL FIXTURES ON DIMMERS
8. EXHAUST HOOD TO EXTERIOR
9. CARBON MONOXIDE ALARMS SHALL BE INSTALLED IN ACCORDANCE WITH SECTION R315 OF THE 2018 IRC

SPRINKLER NOTES:

1. PROVIDE SPRINKLER SYSTEM PER CODE

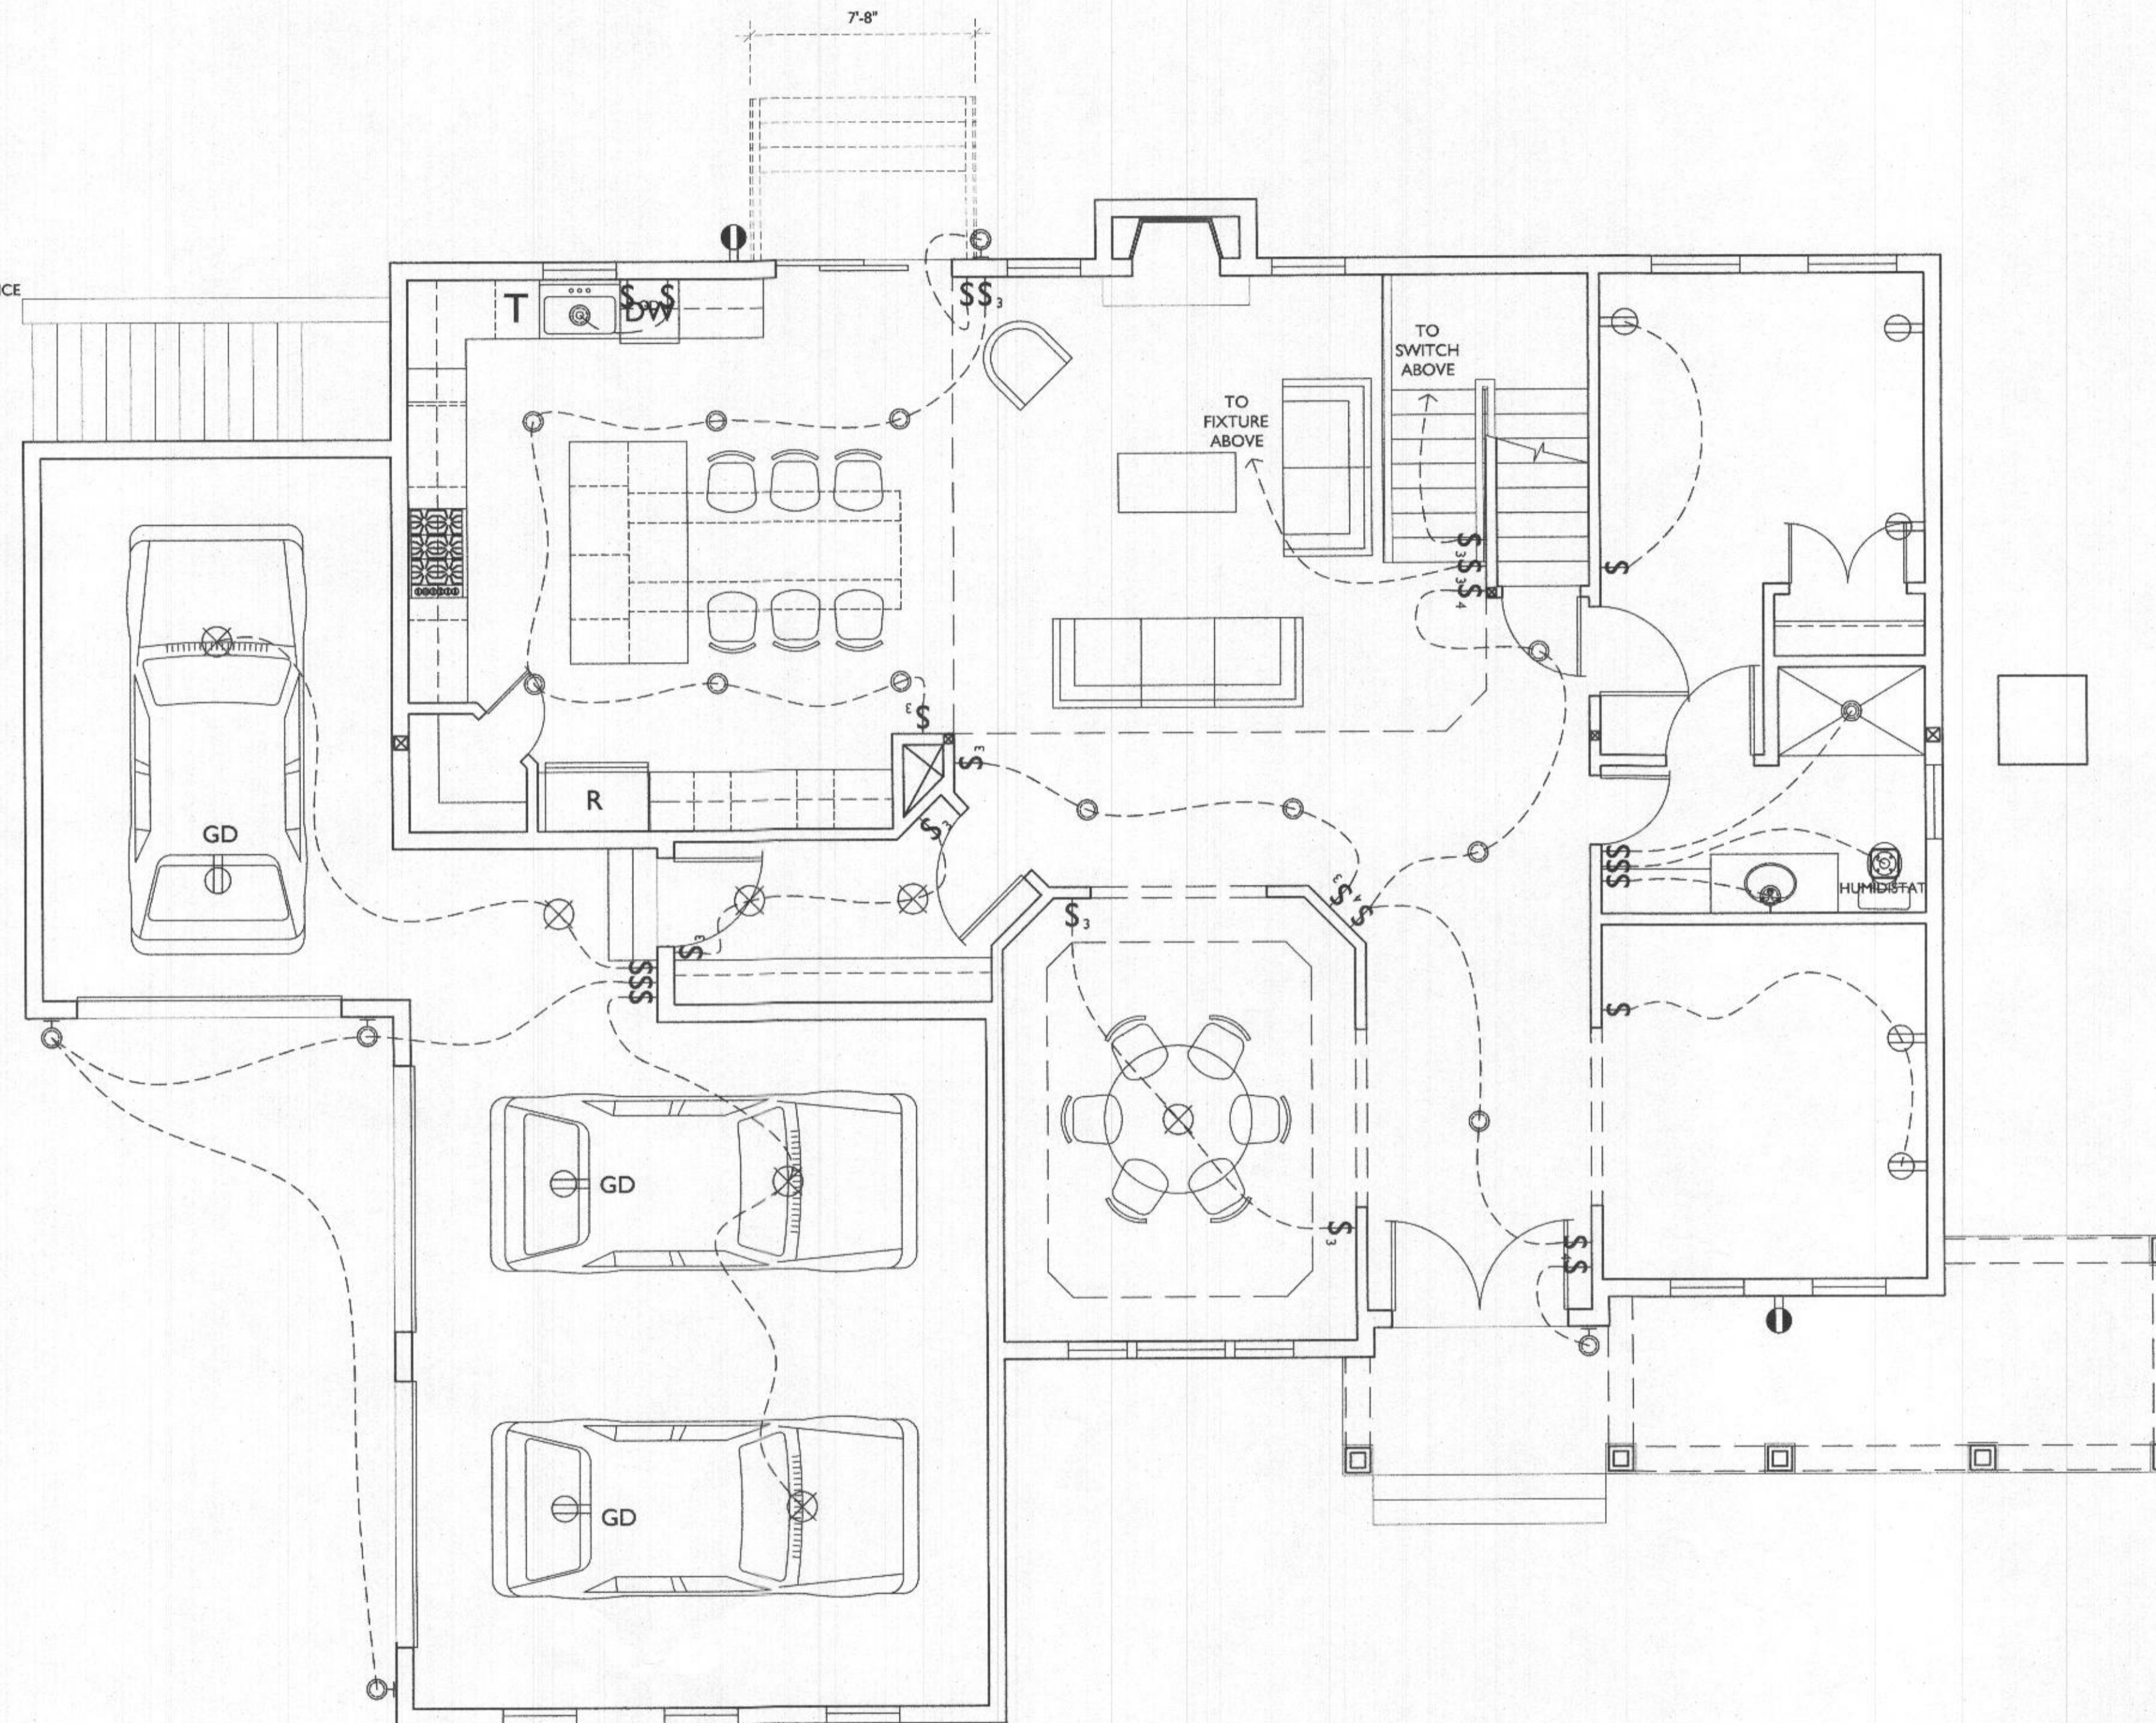

FIRST FLOOR ELECTRICAL PLAN
 SCALE: 1/4"=1'-0"



7612 Browns Bridge Road
 Highland, MD 20777
 301-776-2666
 info@TransformingArchitecture.com
 www.TransformingArchitecture.com



STAMP

I CERTIFY THAT THESE DOCUMENTS WERE PREPARED OR APPROVED BY ME, AND THAT I AM A DULY LICENSED ARCHITECT UNDER THE LAWS OF THE STATE OF MARYLAND, LICENSE NUMBER 13662, EXPIRATION 10-22-2021.

NOTE: THESE DRAWINGS ARE THE PROPERTY OF TRANSFORMING ARCHITECTURE AND, AS SUCH, MAY NOT BE RE-USED OR REPRODUCED, EITHER WHOLLY OR IN PART, WITHOUT PRIOR WRITTEN CONSENT OF TRANSFORMING ARCHITECTURE.

PROJECT PHASE


PERMIT

PROJECT TITLE

THE WIZZARD RESIDENCE

1608 Florence Road
 MT AIRY, MD 21771

REVISIONS

SYMBOL	DATE	ISSUED FOR
	09/14/2021	BUILDING PLAN REVIEW

PROJECT NUMBER 21-594

DATE 07/16/2021

SCALE AS NOTED

DRAWING TITLE

FIRST FLOOR ELECTRICAL PLAN

SHEET NUMBER

E-100

LINE TYPE KEY:
 NEW WALL: [Solid Line]
 ABOVE LINE: [Dashed Line]
 FDN. WALL: [Hatched Line]

ELECTRICAL LEGEND


- ⌚ SWITCH
- ⊖ OUTLET
- ⊖ GFI OUTLET
- RECESSED LED CLG. LIGHT
- ⊖ LED WALL MOUNT FIXTURE
- ⊗ LED CLG. FIXTURE
- ⊖ EXHAUST FAN WITH HUMIDISTAT
- ⊖ CLG. FAN W/ LIGHT
- ⊖ CABLE TV
- ⊖ SD HARDWIRED SMOKE DETECTOR W/INTERNAL BATTERY & CARBON MONOXIDE DETECTOR (COMBINED UNIT)
- ⊖ S SPEAKER
- ⊖ HR HOME RUN ALL SPEAKER WIRES TO THIS LOCATION
- ⊖ 2-HEAD FLOOD
- ⊖ HOSE BIB

ELECTRICAL NOTES:

1. OUTLETS PER CODE @ 18" H, 42" H ABOVE COUNTERTOPS UNLESS OTHERWISE NOTED.
2. MOUNT LIGHT SWITCHES @ 42" H. MAX. ROCKER-TYPE
3. PROVIDE HARD-WIRED SMOKE DETECTORS PER CODE
4. QUIET CLG. FANS W/ LIGHT FIXTURES
5. PROVIDE UNDER-CABINET LIGHTING
6. HINGE SWITCHES IN ALL CLOSETS U.N.O
7. ALL FIXTURES ON DIMMERS
8. EXHAUST HOOD TO EXTERIOR
9. CARBON MONOXIDE ALARMS SHALL BE INSTALLED IN ACCORDANCE WITH SECTION R315 OF THE 2018 IRC

SPRINKLER NOTES:

1. PROVIDE SPRINKLER SYSTEM PER CODE

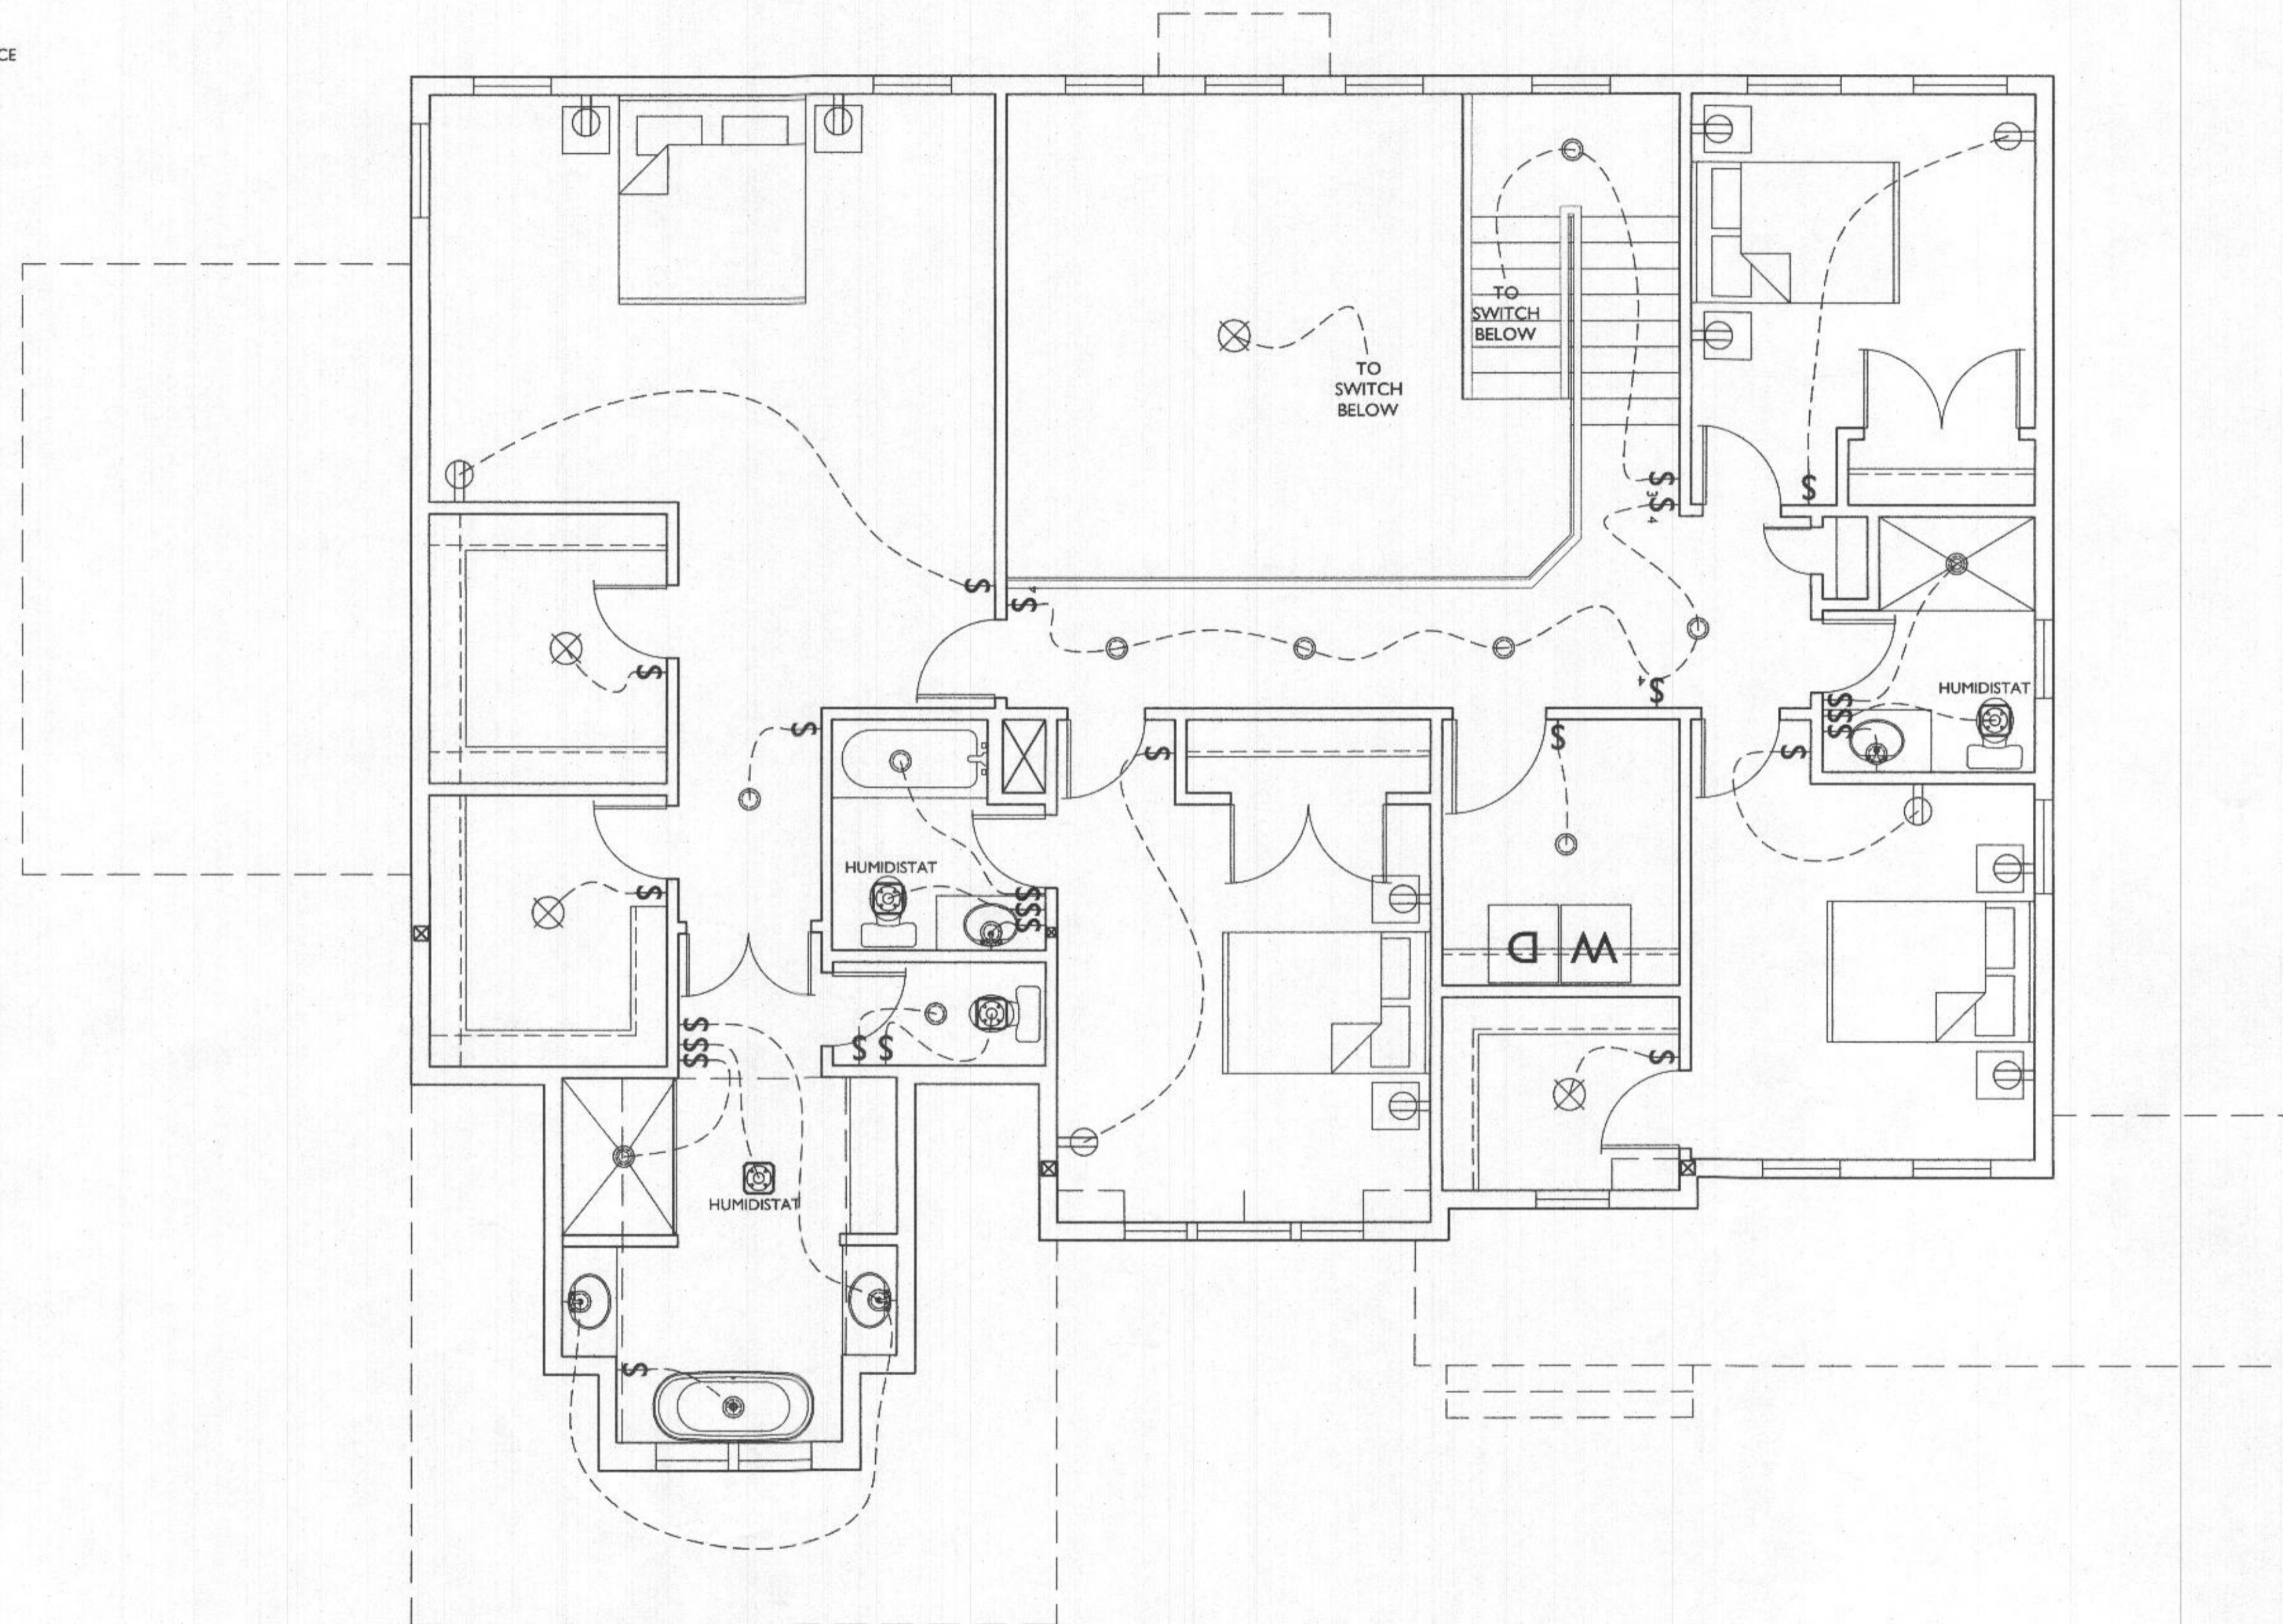

SECOND FLOOR ELECTRICAL PLAN
 SCALE: 1/4"=1'-0"



7612 Browns Bridge Road
 Highland, MD 20777
 301-776-2666
 info@TransformingArchitecture.com
 www.TransformingArchitecture.com



STAMP

I CERTIFY THAT THESE DOCUMENTS WERE PREPARED OR APPROVED BY ME, AND THAT I AM A DULY LICENSED ARCHITECT UNDER THE LAWS OF THE STATE OF MARYLAND, LICENSE NUMBER 13662, EXPIRATION 10-22-2021.

NOTE: THESE DRAWINGS ARE THE PROPERTY OF TRANSFORMING ARCHITECTURE AND, AS SUCH, MAY NOT BE RE-USED OR REPRODUCED, EITHER WHOLLY OR IN PART, WITHOUT PRIOR WRITTEN CONSENT OF TRANSFORMING ARCHITECTURE.

PROJECT PHASE

PERMIT

PROJECT TITLE

THE WIZZARD RESIDENCE

1608 Florence Road
 MT AIRY, MD 21771

REVISIONS

SYMBOL	DATE	ISSUED FOR
▲	09/14/2021	BUILDING PLAN REVIEW

PROJECT NUMBER: 21-594

DATE: 07/16/2021

SCALE: AS NOTED

DRAWING TITLE

SECOND FLOOR ELECTRICAL PLAN

SHEET NUMBER

E-101