

Record Detail \* (This section is required.)

Permit Type	Permit Number	Opened Date
Building/Residential/Misc/Tanks	B22000165	01/19/2022
Description of Work		
SFD/ INSTALL (1) 1,000 GALLON UNDERGROUND PROPANE TANK		

[check spelling](#)

Address \* (This section is required.)

8/24/22 - emailed U. Clancy regarding a revised site plan showing septic. (22)

9/1/22 - revision received →

Approved 9/1/22  
~~AA~~

Search Reset Clear Get Parcel & Owner

Street #	Street Name	Street Type	
7008	COLT	PL	
Unit Type	Unit #	X Coordinate	Y Coordinate
--Select--		-77.00014	39.23327
City	State	Zip Code	Primary
DAYTON	MD	21036	Yes

Parcel \* (This section is required.)

Search Reset Clear Get Address & Owner

GIS ID *	Parcel	Parcel Area	Land Value	Improved Value	Exemption Value	Plan Area
11060800		0	0	0	0	RURAL
Legal Description						

[check spelling](#)

Block	Lot	Census Tract	Council Dist	Inspection Dist	Supervisor Dist	Map #	DAP Zone
18	28	605101	5				
Plan Area	State Tax Id	Subdivision Name					
		Willowshire					
Section	Area	Tax Map					
		27					
Grid	Zoning District	ADC Map					
27-18	RR-DEO	4932-K3					
SDP No.	Final Plan No.	WP File No.					
	ECP-16-025						
Record Plat No.	WS Contract No.	FDP No.	Primary				
25500-2550			Yes				
Owner Occupied	Year Built	Historic District					
<input type="radio"/> Yes <input type="radio"/> No		<input type="radio"/> Yes <input checked="" type="radio"/> No					
Historic District Registry No.	Stat Area	Flood Plain					
	5-01	<input type="radio"/> Yes <input checked="" type="radio"/> No					
Building No							

Owner \* (This section is required.)

Search Reset Clear


Name *	Mail State	Mail Zip Code
TOLL MID ATLANTIC	PA	19044
Address Line 1	Primary	
250 GIBRALTAR ROAD	Yes	
Address Line 2		
Address Line 3		
Mail City		
HORSHAM		
Phone		
301-725-3232		
E-mail		





PROPOSED UNDERGROUND 1,000-GALLON PROPANE STORAGE TANK LOCATION  
**WILLOWSHIRE LOT 28 - 7008 COLT PLACE, DAYTON, MD 21036**  
 SCALE 1" = 30'

THE H.J. POIST GAS COMPANY, INC., 360 MAIN STREET, LAUREL, MD 20707 ~ 301-725-3232 ~ www.poistgas.com

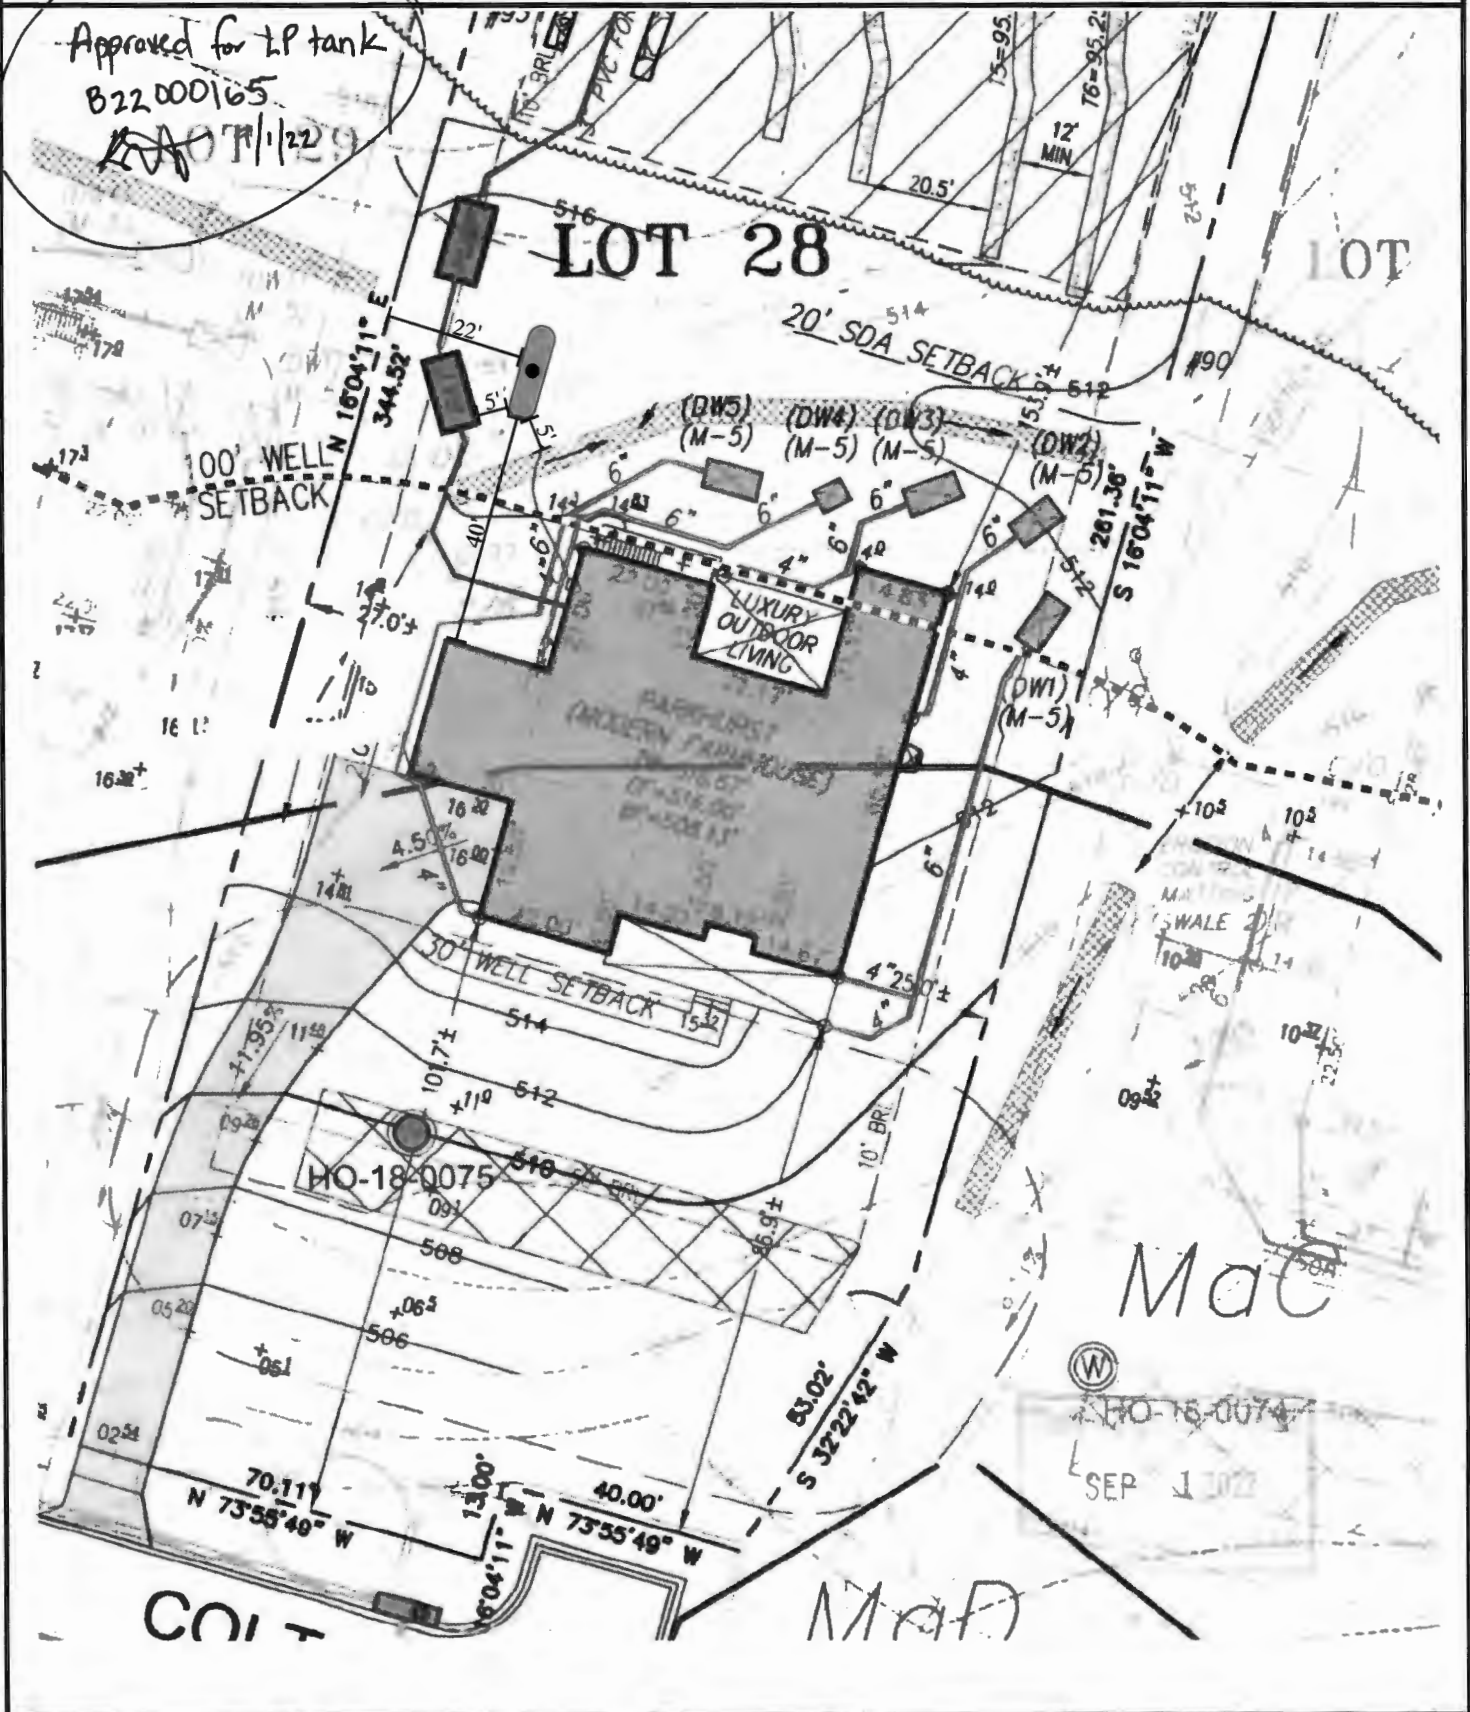

PERMIT NUMBER: B 22000618

DATE ACCEPTED: 2/23/2022



RESIDENTIAL BUILDING PERMIT APPLICATION

HOWARD COUNTY DEPARTMENT OF INSPECTIONS, LICENSES, AND PERMITS
3430 COURT HOUSE DRIVE, ELLICOTT CITY, MD 21043 PHONE: (410) 313-2455 OPTION #4
www.howardcountymd.gov

BUILDING SITE ADDRESS REQUIRED

Street Address: 7008 Colt Place Unit:
City: Dayton State: MD Zip Code: 21036
Subdivision/Village/Complex Name: Willowshire SDP/WP/BA #:
Lot: 28 Tax Map: Parcel: Grading Permit #:

DESCRIPTION OF WORK REQUIRED

Existing Use: vacant lot Proposed Use: SFD Estimated Cost: \$ 300,000
Trade Work to Be Completed (Separate Permits Required): Mechanical (HVACR) Electrical Plumbing None
New 2 story "Parkhurst" Modern Farmhouse etc, 2 car side load garage, 1 car side attached garage, Multi-gon suite, luxury covered deck and unfinished lower level

PROPERTY OWNER INFORMATION REQUIRED

Owner(s) Name(s) (As it appears on tax records): Toll Mid Atlantic Lp. Co. Inc. Contact: Summer Riley Primary Residence: Yes No
Owner's Street Address: 250 Gibraltar Road
City: Horsham State: PA Zip Code: 19044
Phone: 410-872-9105 Email: sriley1@tollbrothers.com

APPLICANT NAME REQUIRED - INDIVIDUAL WHO SIGNS THIS APPLICATION

Business Name: Decatur Building Services Contact Name: Jim Kerwin
Street Address: PO Box 552
City: Woodbine State: MD Zip Code: 21797
Phone: 443-309-7792 Email: jim@decaturbuildingservices.com

CONTRACTOR INFORMATION REQUIRED

Business Name: Toll Brothers Contact: Summer Riley
Licensee's Name: Toll Mid Atlantic Lp. Co. Inc. License #: 8220
Street Address: 6731 Columbia Gateway Drive, Suite 120
City: Columbia State: MD Zip Code: 21046
Phone: 410-872-9105 Email: sriley1@tollbrothers.com

ARCHITECT/ENGINEER INFORMATION INDIVIDUAL WHO SIGNED PLANS, IF APPLICABLE

Business Name: Name:
Street Address:
City: State: Zip Code:
Phone: Email:

BUILDING CHARACTERISTICS REQUIRED

Primary Structure: SF Dwelling SF Townhouse SF Duplex Mobile Home Multi-Family Dwelling (MF\*) Condo: Yes No
Utilities: Electric Gas Water Supply: Public Private (Well) Sewage Disposal: Public Private (Septic)
Heating System: Electric Natural Gas Propane Other: Roadside Tree Project: No Yes: #
Sprinkler System: NFPA 13 NFPA 13R NFPA 13D None Fire Alarm System: Yes No Voice Evac

ADDITIONAL RESIDENTIAL INFORMATION (PLEASE SELECT/COMPLETE ALL THAT APPLY)

Model Name & Options: "Parkhurst" Modern Farmhouse, 2 car + 1 car garage, luxury deck, Multi-gon suite, ULL
# of Bedrooms (SF): 5 # of efficiency units (MF\*): # of 1 BR (MF\*): # of 2 BR (MF\*): # of 3 BR (MF\*):
# Rooms: 12 # Full Baths: 5 # Half Baths: 1 # Fireplaces: 1
Garage/Carport Info: Attached Garage Detached Garage Integral Garage Carport None
Basement/Foundation Info: Slab on Grade Post & Pier Unfinished Basement Finished Basement: Full or Partial
1st Fl Width: 73 1st Fl Depth: 72 2nd Fl Width: 59 2nd Fl Depth: 56 Bsmt Width: 59 Bsmt Depth: 72
Energy Method: Prescriptive Performance UA Alternative ERI Gross Area: 8449 sq ft Occupiable Area: 8183 sq ft

AGREEMENT/ DISCALIMER REQUIRED

THE UNDERSIGNED HEREBY CERTIFIES AND AGREES AS FOLLOWS: (1) THAT HE/SHE IS AUTHORIZED TO MAKE THIS APPLICATION, (2) THAT THE INFORMATION IS CORRECT, (3) THAT HE/SHE WILL COMPLY WITH ALL REGULATIONS OF HOWARD COUNTY WHICH ARE APPLICABLE THERETO, (4) THAT HE/SHE WILL PERFORM NO WORK ON THE ABOVE REFERENCED PROPERTY NOT SPECIFICALLY DESCRIBED IN THIS APPLICATION, (5) THAT HE/SHE GRANTS COUNTY OFFICIALS THE RIGHT TO ENTER ONTO THIS PROPERTY FOR THE PURPOSE OF INSPECTING THE WORK PERMITTED AND POSTING NOTICES

APPLICANT'S ORIGINAL SIGNATURE: Jim Kerwin DATE SIGNED: 2/22/2022

FOR OFFICE USE ONLY

CHECKS PAYABLE TO: DIRECTOR OF FINANCE OF HOWARD COUNTY


AGENCIES REQUIRED/APPROVALS: PR DPZ DED Health SHA CID
SUBMITTAL FEES: \$150 PAYMENT: CK# 00116726 ACCEPTED BY: ??

PROFESSIONAL CERTIFICATION: I HEREBY CERTIFY THAT THESE DOCUMENTS WERE PREPARED BY ME OR UNDER MY RESPONSIBLE CHARGE, AND THAT I AM A DULY LICENSED PROFESSIONAL LAND SURVEYOR UNDER THE LAWS OF THE STATE OF MARYLAND, LICENSE NO. 21328, EXPIRATION DATE 1/8/23.

**LEGEND:**

- BRL BUILDING RESTRICTION LINE
- WELL LOCATION
- T.W. TOP OF WALL
- G.F. GARAGE FLOOR
- B.F. BASEMENT FLOOR
- PASSED PERC LOCATION
- SEWAGE DISPOSAL AREA
- WELL BOX AREA
- PROPOSED TREE
- SCE STONE CONSTRUCTION ENTRANCE
- SILT FENCE
- SUPER SILT FENCE
- LIMITS OF DISTURBANCE

NOTE:  
TOTAL LIMITS OF DISTURBANCE (LOD) = 31,881 SQ. FT.

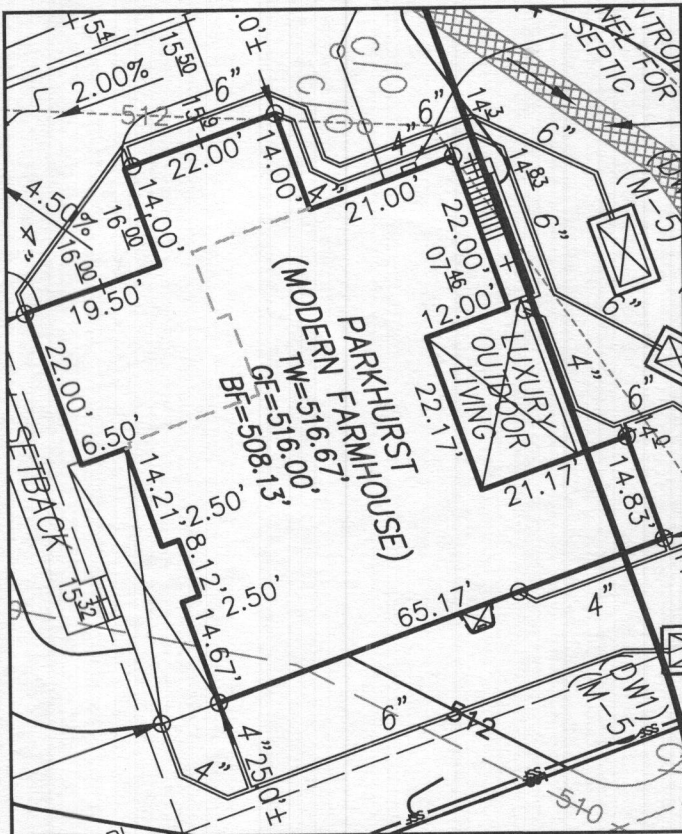

BUILDING SETBACKS (B.R.L.'s) SHOWN HEREON PER SITE DEVELOPMENT PLAN  
SETBACK DISTANCES SHOWN HEREON AS "±" HAVE AN ACCURACY OF ±0.1' FOOT.

HOUSE TYPE: PARKHURST (MODERN FARMHOUSE)

TWO CAR SIDE ENTRY GARAGE	OPTION No. 012
FINISHED LOWER LEVEL	OPTION No. 013
DAYLIGHT BASEMENT	OPTION No. 018
MULTI-GENERATIONAL SUITE ADDITION	OPTION No. 263073
ADDITIONAL 1 CAR FRONT ENTRY GARAGE (14')	OPTION No. 263102
LUXURY OUTDOOR LIVING	OPTION No. 263165

WELL NUMBER: HO-18-0075


ADDRESS: 7008 COLT PLACE  
DAYTON, MD 21036

PERMIT PLOT PLAN  
LOT 28  
**WILLOSHIRE**  
LIBER 18479, FOLIO 296  
PLAT NO. 25505  
5th ELECTION DISTRICT  
HOWARD COUNTY, MARYLAND

**ESE CONSULTANTS**  
ENGINEERING • PLANNING • SURVEYING • ENVIRONMENTAL

ESE Consultants, Inc.  
6731 Columbia Gateway Drive • Suite 120 • Columbia, MD 21046  
T: 410-872-9105


DATE: 01/24/2022    SCALE: 1" = 30'    FILE: PP LOT 28 - PARKHURST MF.\_rev2  
CHK'D: M.J.B.    JOB NO: 4520    DRAWN: R.C.K.

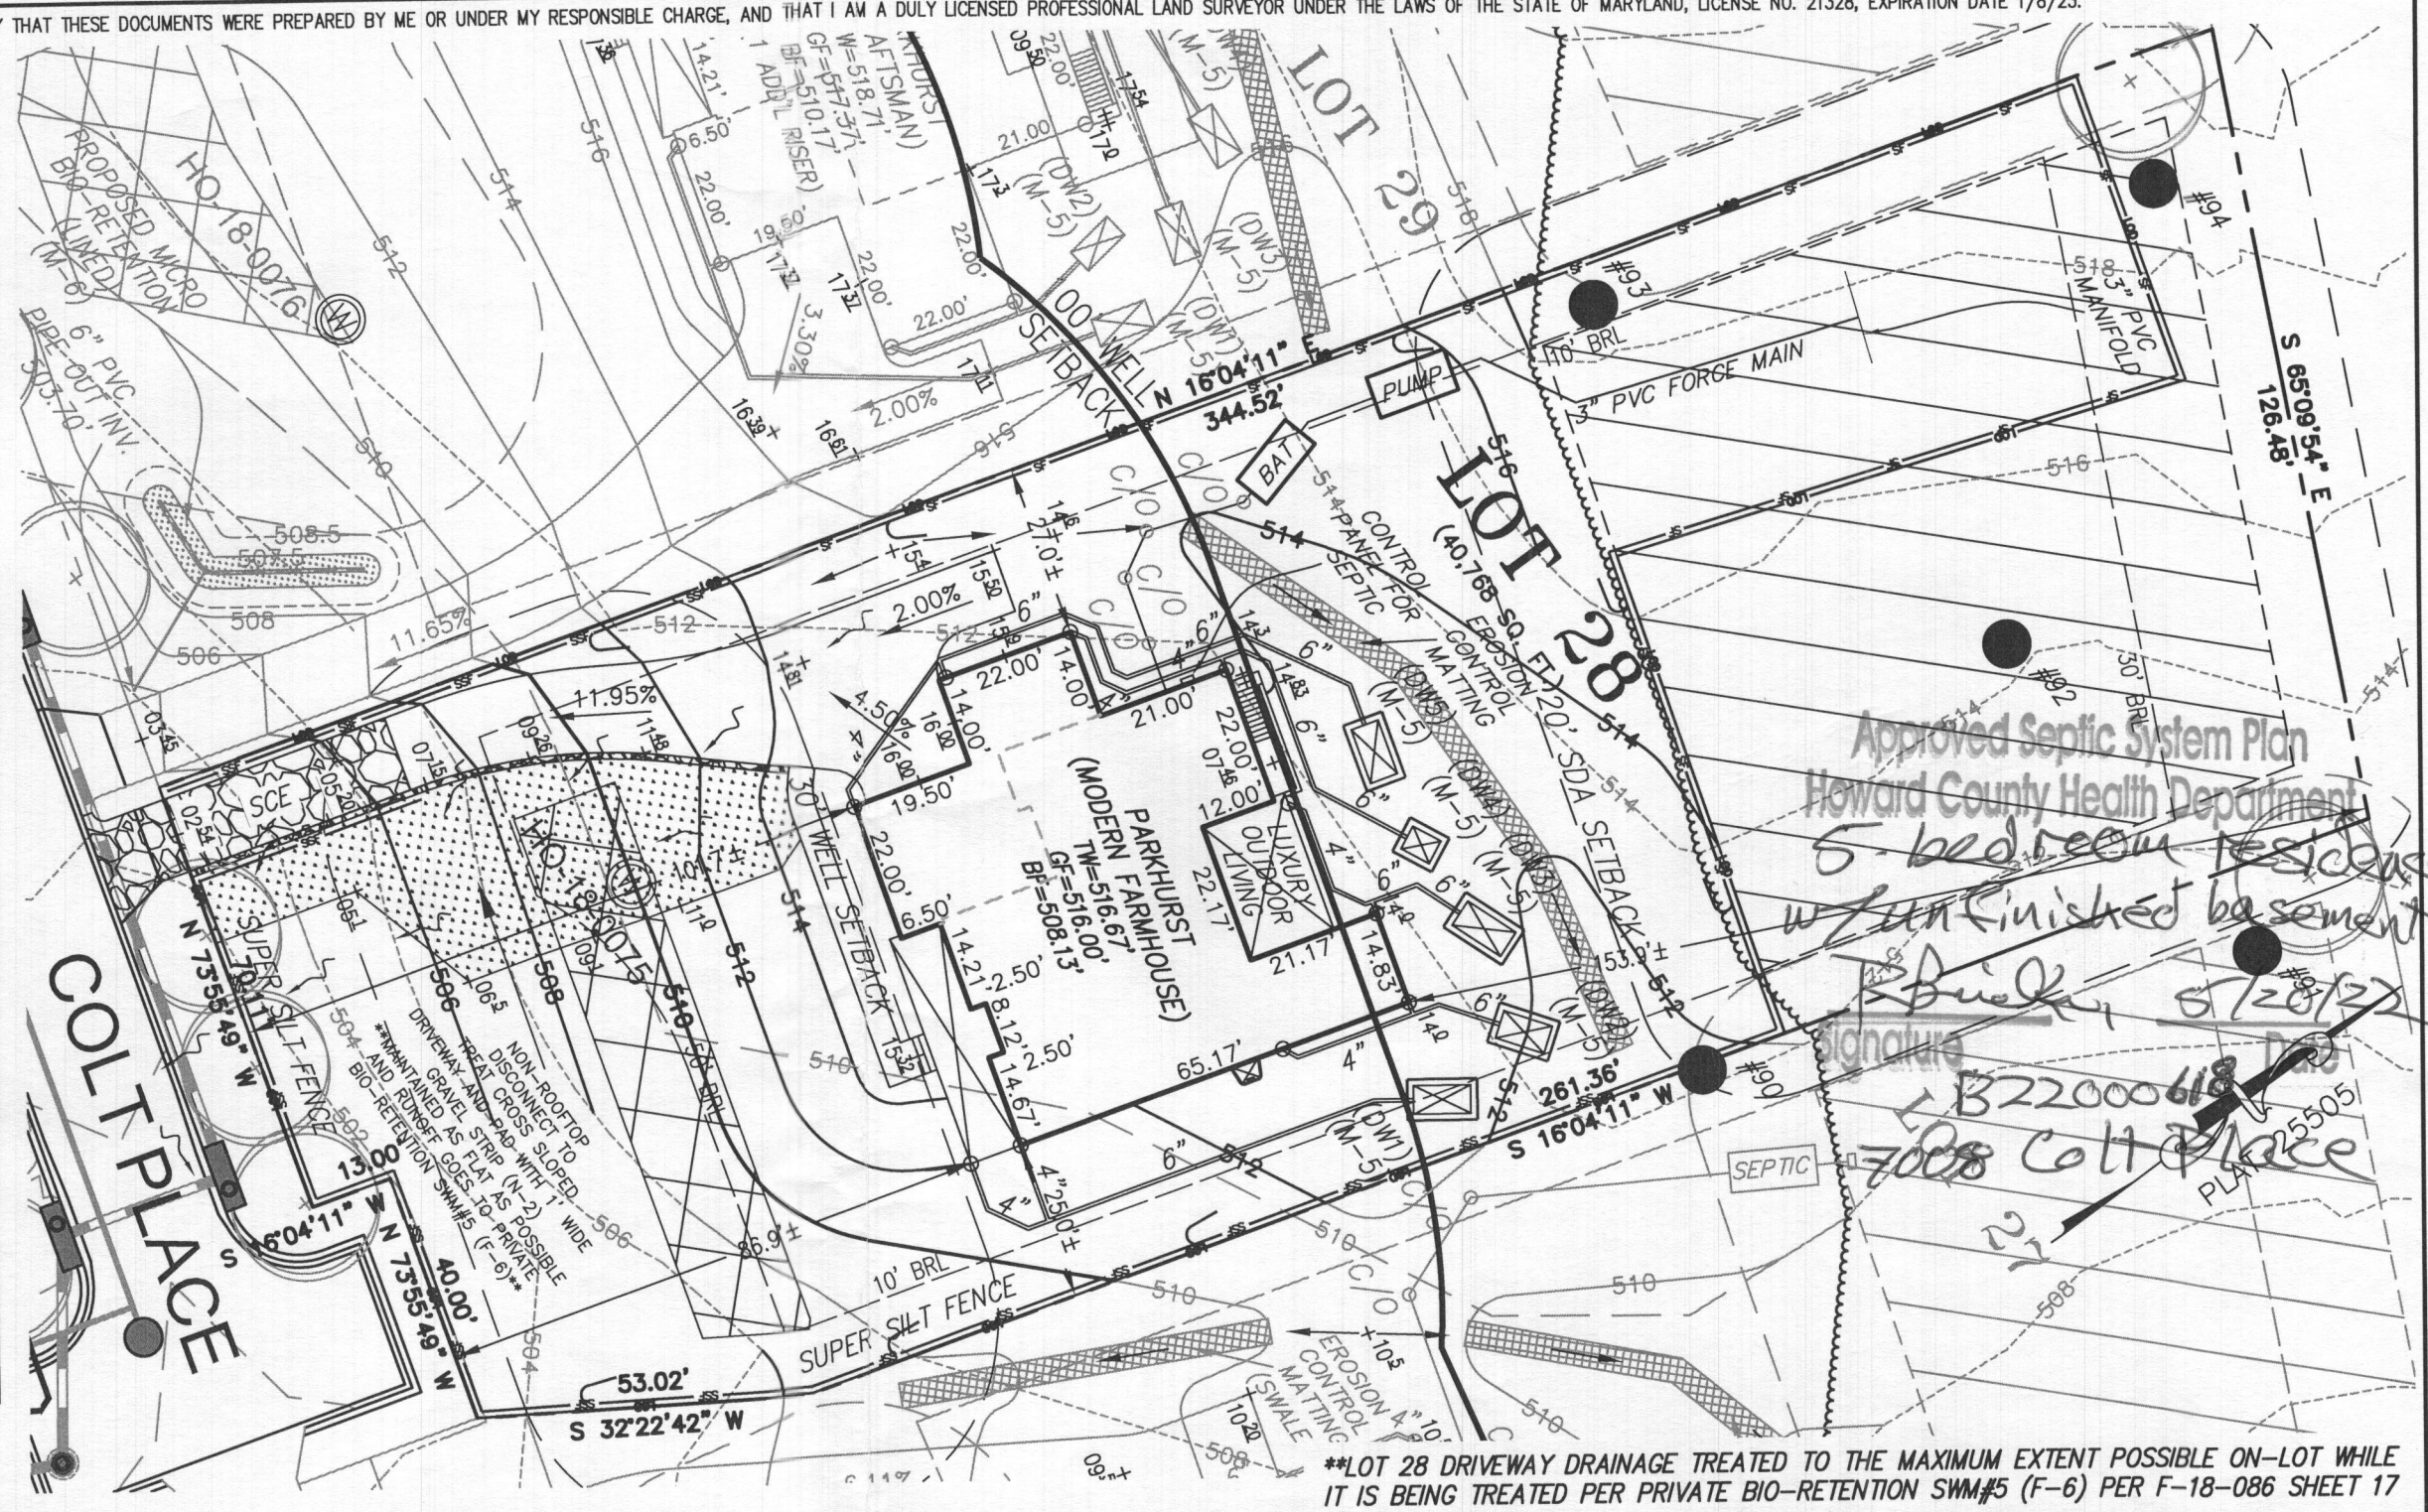

# Health Dept

- GENERAL PLAN NOTES**
- A. ALL WOOD STUD PARTITIONS NOT DIMENSIONED ARE TO BE 3 1/2" FOR INTERIOR AND 5 1/2" FOR EXTERIOR WALLS UNLESS OTHERWISE NOTED.
  - B. ALL INTERIOR DIMENSIONS ARE TO FACE OF STUDS.
  - C. ALL EXTERIOR DIMENSIONS ARE TO FACE OF STUDS.
  - D. ALL DIMENSIONS GOVERN OVER SCALE.
  - E. ALL SMOKE DETECTORS ARE TO BE WIRED IN SUCH A MANNER THAT ACTIVATION OF ONE WILL ACTIVATE THEM ALL.
  - F. ENCLOSED ACCESSIBLE SPACE UNDER STAIRS SHALL HAVE WALLS AND SOFFITS PROTECTED ON ENCLOSED SIDE WITH 1/2" GYPSUM BOARD.
  - G. ALL WINDOWS SIZE ARE NOTED IN FEET + INCHES AS MEASURED FROM SASH TO SASH.
  - H. REFER TO ELEVATIONS FOR WINDOW HEAD HEIGHTS.
  - I. ALL DOORS ARE TO BE 6'-8" HIGH UNLESS OTHERWISE NOTED.
  - J. WASHER ALWAYS TO BE ON LEFT SIDE OF DRYER.
  - K. DISHWASHER ALWAYS TO BE ON RIGHT SIDE OF SINK.

7008 Colt Place  
 Lot 28  
 willowshire

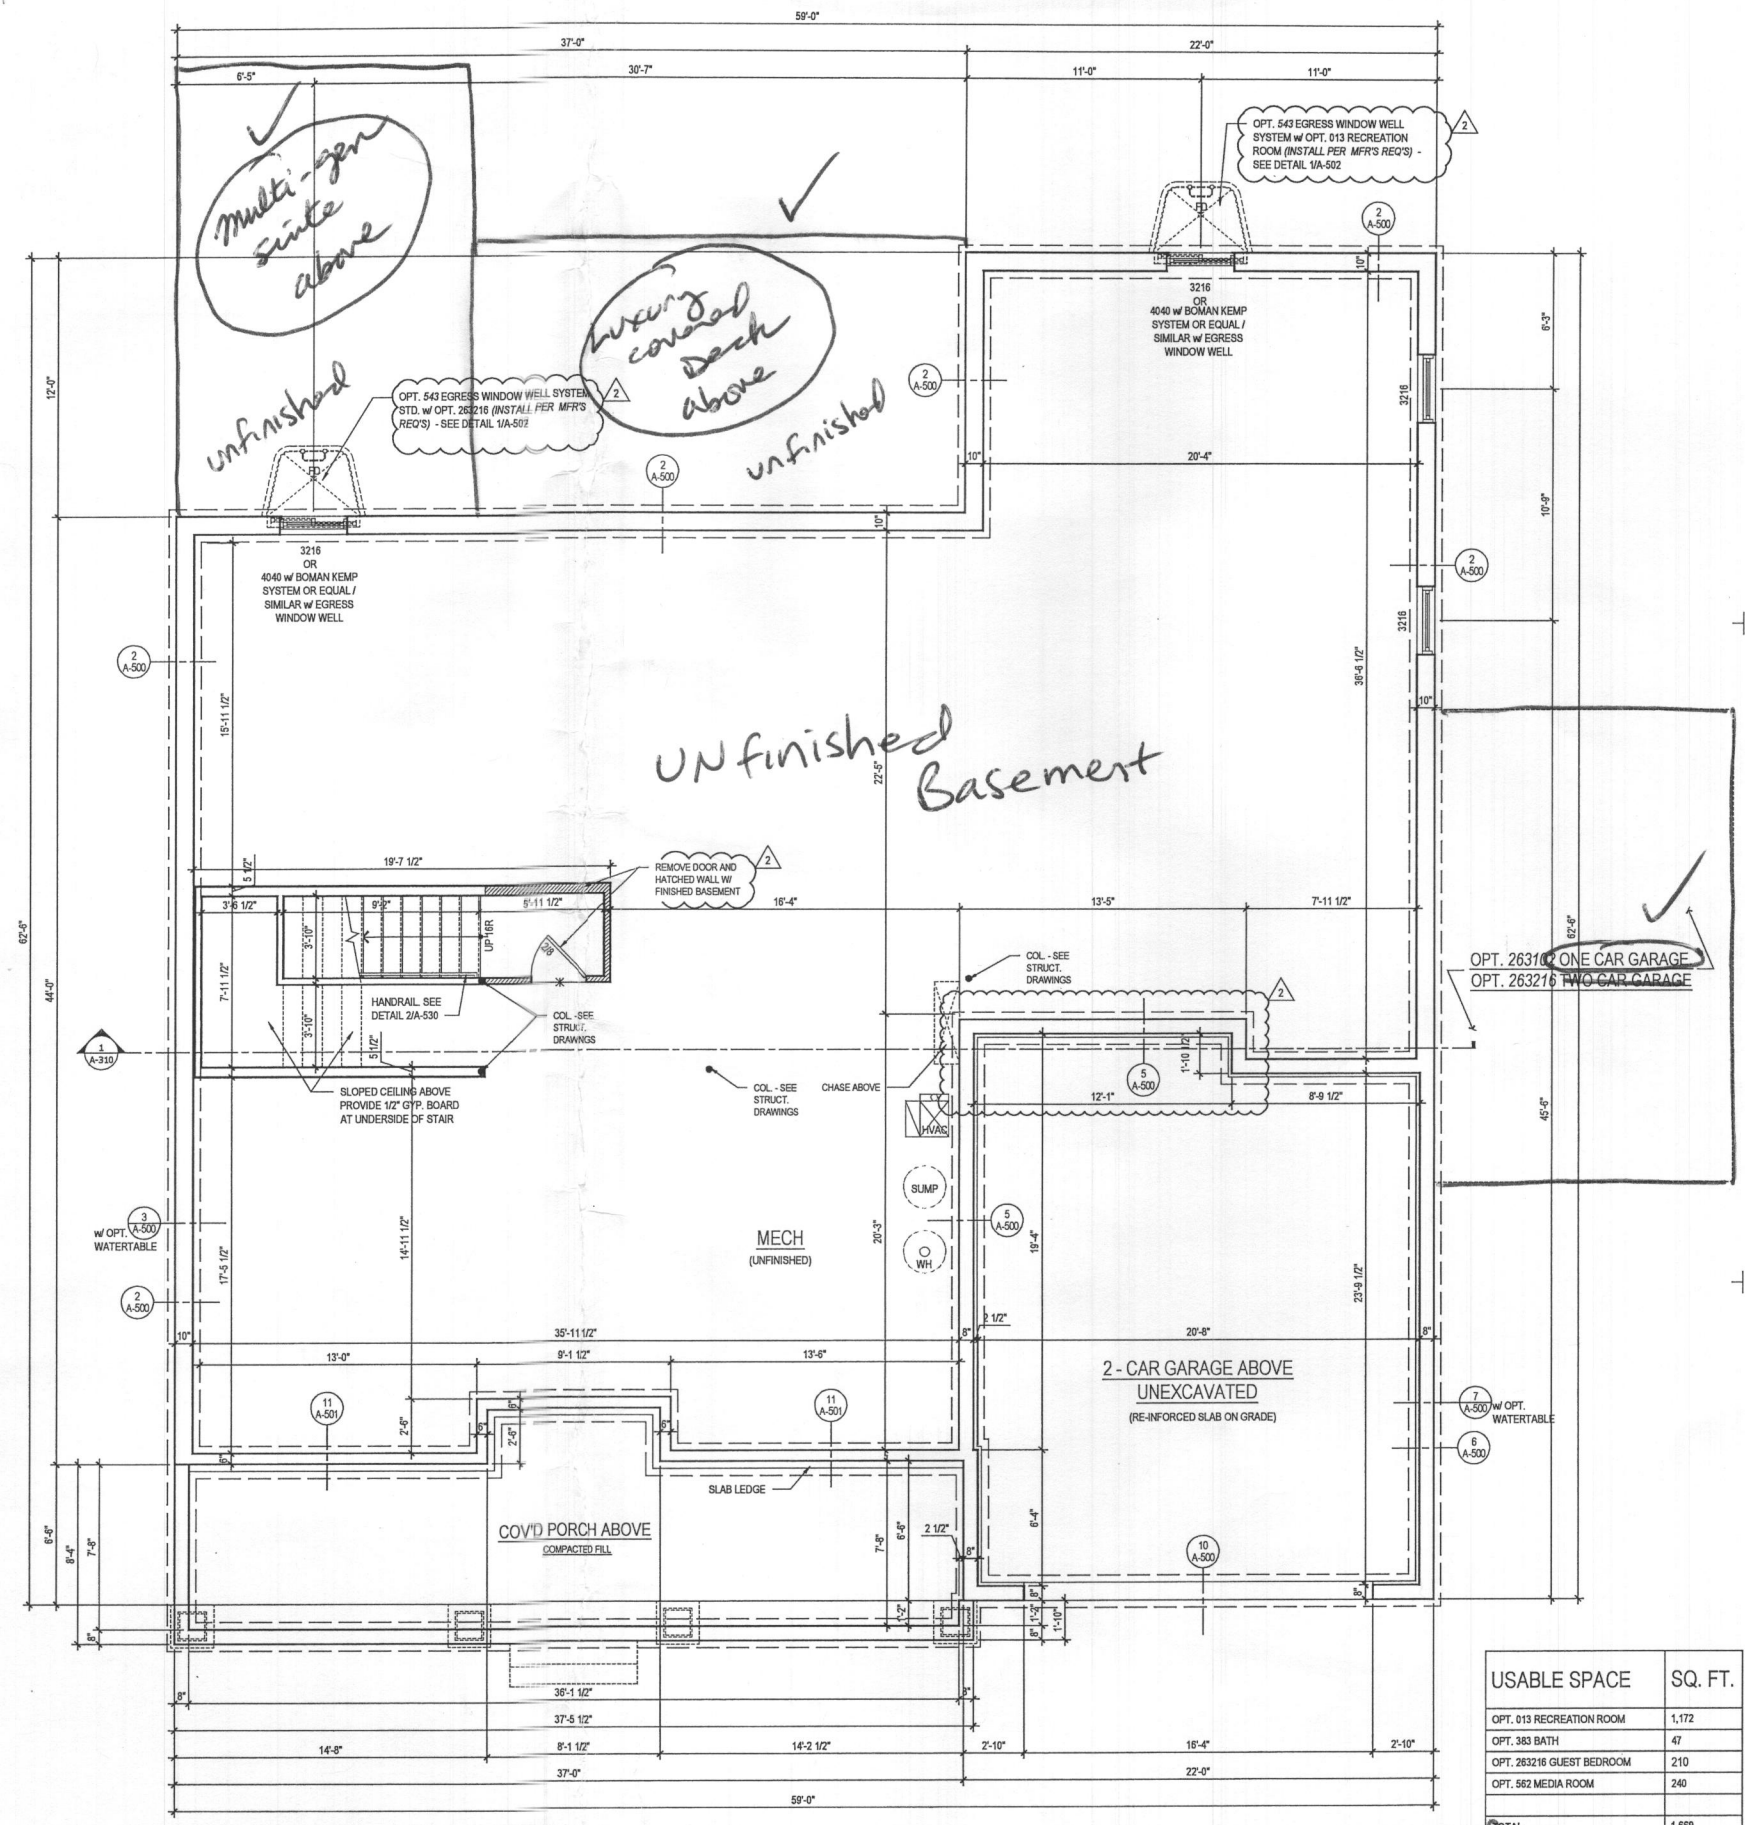

1 BASEMENT FLOOR PLAN  
 A-100 SCALE: 1/4"=1'-0"  
 TOL081a\_A100.DWG

@ ELEV. 1 - CRAFTSMAN  
 @ UNFINISHED CONDITION  
 shown

USABLE SPACE	SQ. FT.
OPT. 013 RECREATION ROOM	1,172
OPT. 383 BATH	47
OPT. 283216 GUEST BEDROOM	210
OPT. 582 MEDIA ROOM	240
TOTAL	1,669

ARCHITECT:  
  
 lessard DESIGN  
 8521 Leesburg Pike  
 Suite 700 | Vienna, VA 22182  
 P: 571.830.1800 | F: 571.830.1801  
 www.lessarddesign.com

SEAL & SIGNATURE:

OWNER:  
 TOLL BROTHERS  
 19775 BELMONT EXECUTIVE PLAZA  
 ASHBURN, VA 20147  
 P: 571.291.8068  
 CONTACT: CHRISTINA LEMLEY  
 demley@tollbrothers.com

PROJECT NAME: MARYLAND  
 SHEET TITLE: PARKHURST FLOOR PLANS

ISSUE / REVISION

NO.	DESCRIPTION	DATE
BID SET		05.29.19
PERMIT SET		06.19.19
1	MD NEW STANDARDS	09.16.19
2	MFR #220241	12.11.20


PROJECT No: TOL081a  
 DRAWN BY: ACB  
 CHECKED BY: AP  
 PLOT DATE: Jan. 20, 2021  
 FILE NAME: TOL081a\_A100.dwg

A-100


1522000018

See additional pages for "Modern farmhouse" E/W

- GENERAL PLAN NOTES**
- A. ALL WOOD STUD PARTITIONS NOT DIMENSIONED ARE TO BE 3 1/2" FOR INTERIOR AND 5 1/2" FOR EXTERIOR WALLS UNLESS OTHERWISE NOTED.
  - B. ALL INTERIOR DIMENSIONS ARE TO FACE OF STUDS.
  - C. ALL EXTERIOR DIMENSIONS ARE TO FACE OF STUDS.
  - D. ALL DIMENSIONS GOVERN OVER SCALE.
  - E. ALL SMOKE DETECTORS ARE TO BE WIRED IN SUCH A MANNER THAT ACTIVATION OF ONE WILL ACTIVATE THEM ALL.
  - F. ENCLOSED ACCESSIBLE SPACE UNDER STAIRS SHALL HAVE WALLS AND SOFFITS PROTECTED ON ENCLOSED SIDE WITH 1/2" GYPSUM BOARD.
  - G. ALL WINDOWS SIZE ARE NOTED IN FEET + INCHES AS MEASURED FROM SASH TO SASH.
  - H. REFER TO ELEVATIONS FOR WINDOW HEAD HEIGHTS.
  - I. ALL DOORS ARE TO BE 6'-8" HIGH UNLESS OTHERWISE NOTED.
  - J. WASHER ALWAYS TO BE ON LEFT SIDE OF DRYER.
  - K. DISHWASHER ALWAYS TO BE ON RIGHT SIDE OF SINK.

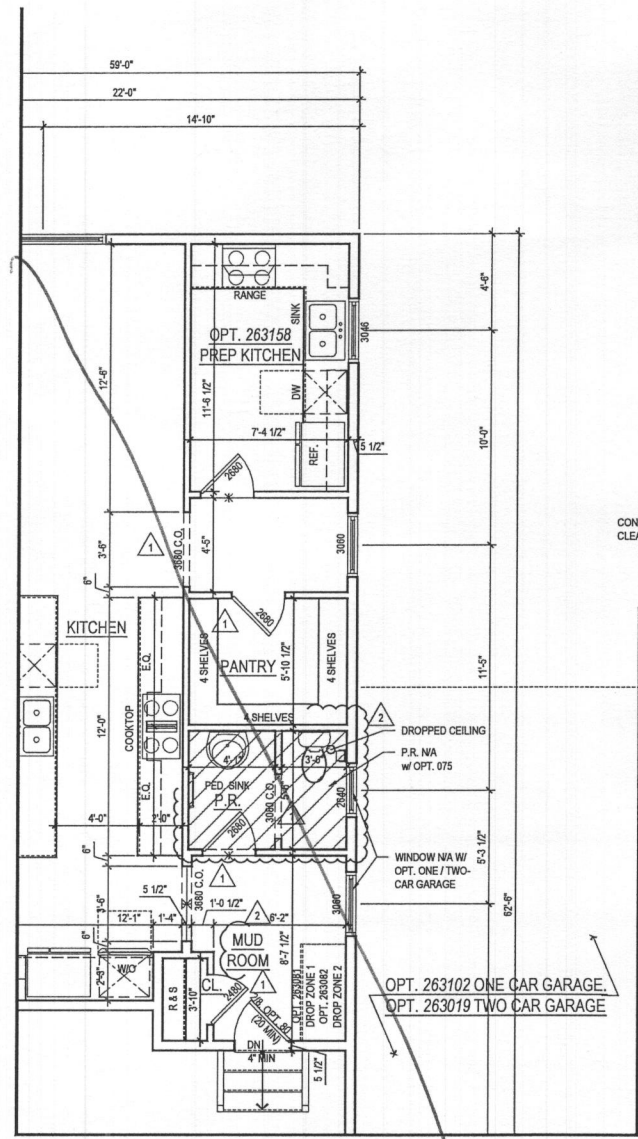

**2 PART. FIRST FLOOR PLAN w/ OPT. 263158 - OPT. PREP KITCHEN**  
 A-110 SCALE: 1/4"=1'-0"  
 TOL081A\_A110.DWG

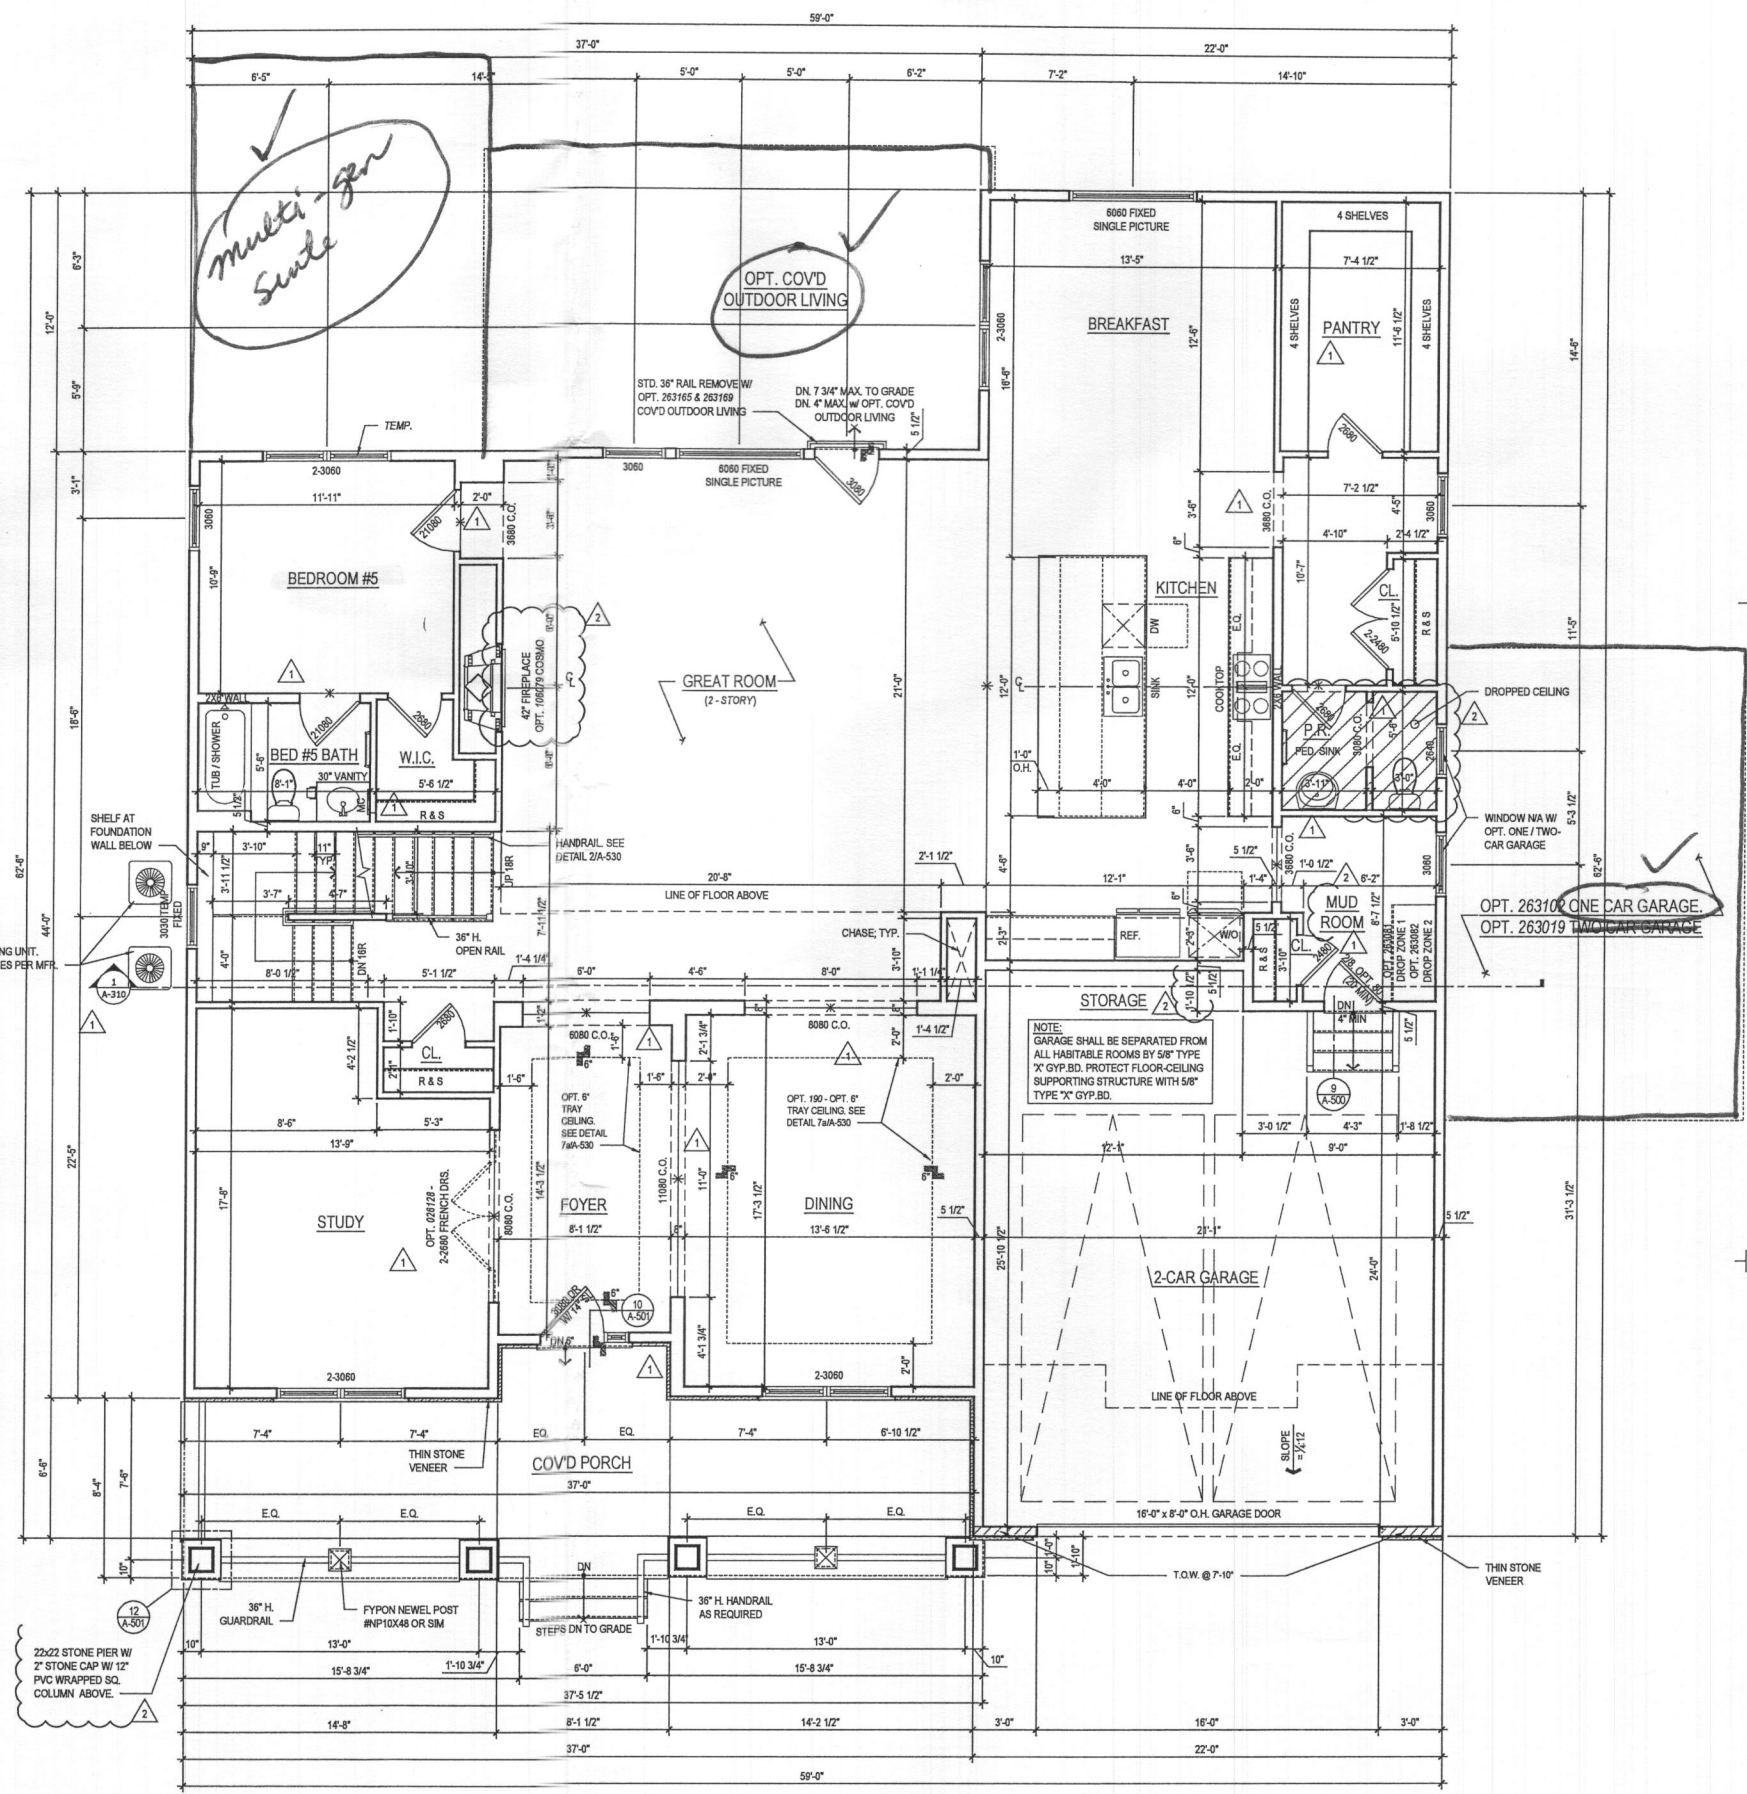

**1 FIRST FLOOR PLAN**  
 A-110 SCALE: 1/4"=1'-0"  
 TOL081A\_A110.DWG

@ ELEV. 1 - CRAFTSMAN *shown*  
 See additional pages for "Modernfarm house" elev

ARCHITECT:  
**lessard DESIGN**  
 8521 Leesburg Pike  
 Suite 700 | Vienna, VA 22182  
 P: 571.830.1800 | F: 571.830.1801  
 www.lessarddesign.com

SEAL & SIGNATURE:

OWNER:  
**TOLL BROTHERS**  
 19775 BELMONT EXECUTIVE PLAZA  
 ASHBURN, VA 20147  
 P: 571.291.8068  
 CONTACT: CHRISTINA LEHLEY  
 clemley@tollbrothers.com

PROJECT NAME: MARYLAND  
 SHEET TITLE: PARKHURST FLOOR PLANS


ISSUE / REVISION		
NO.	DESCRIPTION	DATE
1	BID SET	05.29.19
1	PERMIT SET	06.19.19
1	MD NEW STANDARDS	09.16.19
2	MR #220241	12.11.20

PROJECT No: TOL081A  
 DRAWN BY: AC/RSK  
 CHECKED BY: AS  
 PLOT DATE: 10/20/2022  
 FILE NAME: TOL081A\_A110.dwg

**A-110**


File No: TOL081A\_A110.dwg  
 Plot By: analk

- GENERAL PLAN NOTES**
- A. ALL WOOD STUD PARTITIONS NOT DIMENSIONED ARE TO BE 3 1/2" FOR INTERIOR AND 5 1/2" FOR EXTERIOR WALLS UNLESS OTHERWISE NOTED.
  - B. ALL INTERIOR DIMENSIONS ARE TO FACE OF STUDS.
  - C. ALL EXTERIOR DIMENSIONS ARE TO FACE OF STUDS.
  - D. ALL DIMENSIONS GOVERN OVER SCALE.
  - E. ALL SMOKE DETECTORS ARE TO BE WIRED IN SUCH A MANNER THAT ACTIVATION OF ONE WILL ACTIVATE THEM ALL.
  - F. ENCLOSED ACCESSIBLE SPACE UNDER STAIRS SHALL HAVE WALLS AND SOFFITS PROTECTED ON ENCLOSED SIDE WITH 1/2" GYPSUM BOARD.
  - G. ALL WINDOWS SIZE ARE NOTED IN FEET + INCHES AS MEASURED FROM SASH TO SASH.
  - H. REFER TO ELEVATIONS FOR WINDOW HEAD HEIGHTS.
  - I. ALL DOORS ARE TO BE 6'-8" HIGH UNLESS OTHERWISE NOTED.
  - J. WASHER ALWAYS TO BE ON LEFT SIDE OF DRYER.
  - K. DISHWASHER ALWAYS TO BE ON RIGHT SIDE OF SINK.

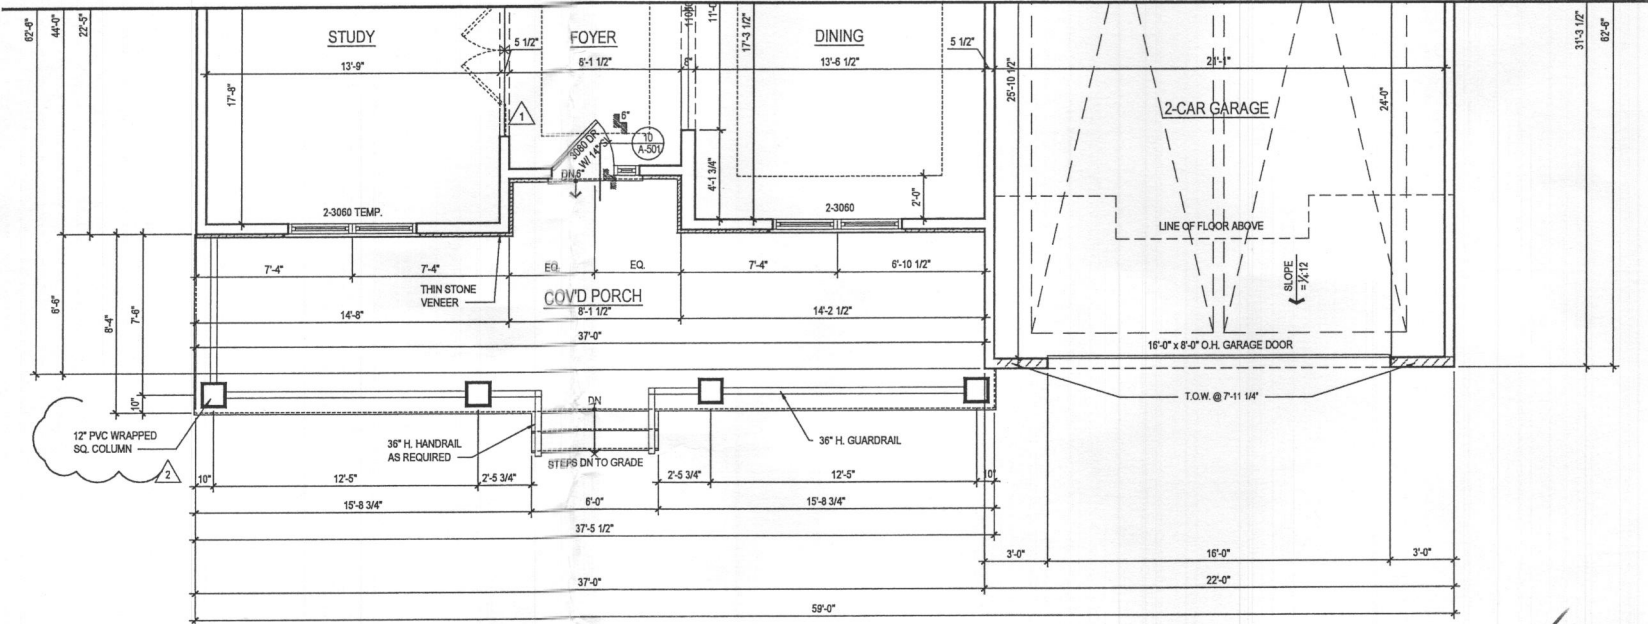

**2 FIRST FLOOR PLAN**  
A-140 SCALE: 1/4"=1'-0"  
TOL0818\_A140.DWG

@ ELEV. 2 - MODERN FARMHOUSE

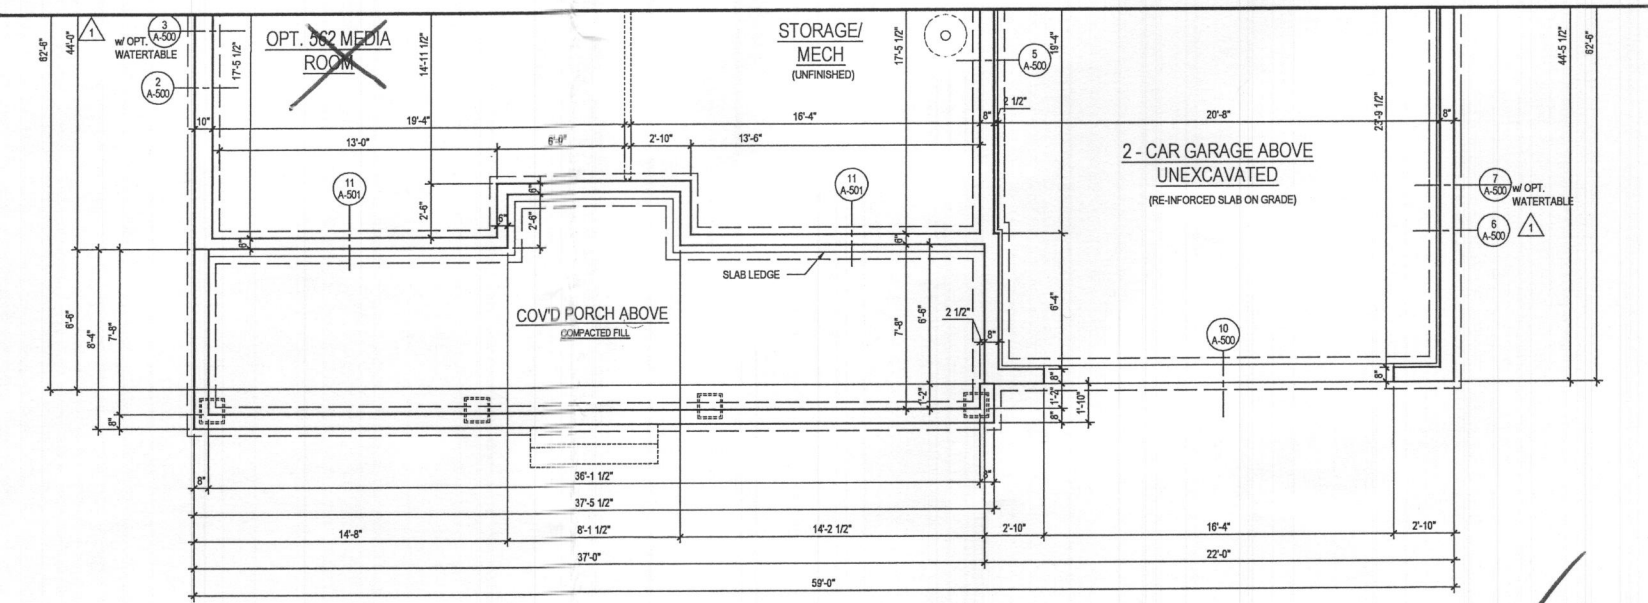

**1 BASEMENT FLOOR PLAN**  
A-140 SCALE: 1/4"=1'-0"  
TOL0818\_A140.DWG

@ ELEV. 2 - MODERN FARMHOUSE

ARCHITECT:

8521 Leesburg Pike  
Suite 700 | Vienna, VA 22182  
P: 571.830.1800 | F: 571.830.1801  
www.lessarddesign.com

SEAL & SIGNATURE:

OWNER:

**TOLL BROTHERS**  
19775 BELMONT EXECUTIVE PLAZA  
ASHBURN, VA 20147  
P: 571.291.8068  
CONTACT: CHRISTINA LEMLEY  
clemley@tollbrothers.com

PROJECT NAME:

MARYLAND

**PARKHURST FLOOR PLANS**


SHEET TITLE:

ISSUE / REVISION

NO.	DESCRIPTION	DATE
BID SET		05.29.19
PERMIT SET		06.19.19
1	MD NEW STANDARDS	09.16.19
2	MR #220241	12.11.20


PROJECT No: TOL0818  
DRAWN BY: AC/ML  
CHECKED BY: ML  
PLOT DATE: Jan. 20, 2021  
FILE NAME: TOL0818\_A140.dwg

**A-140**

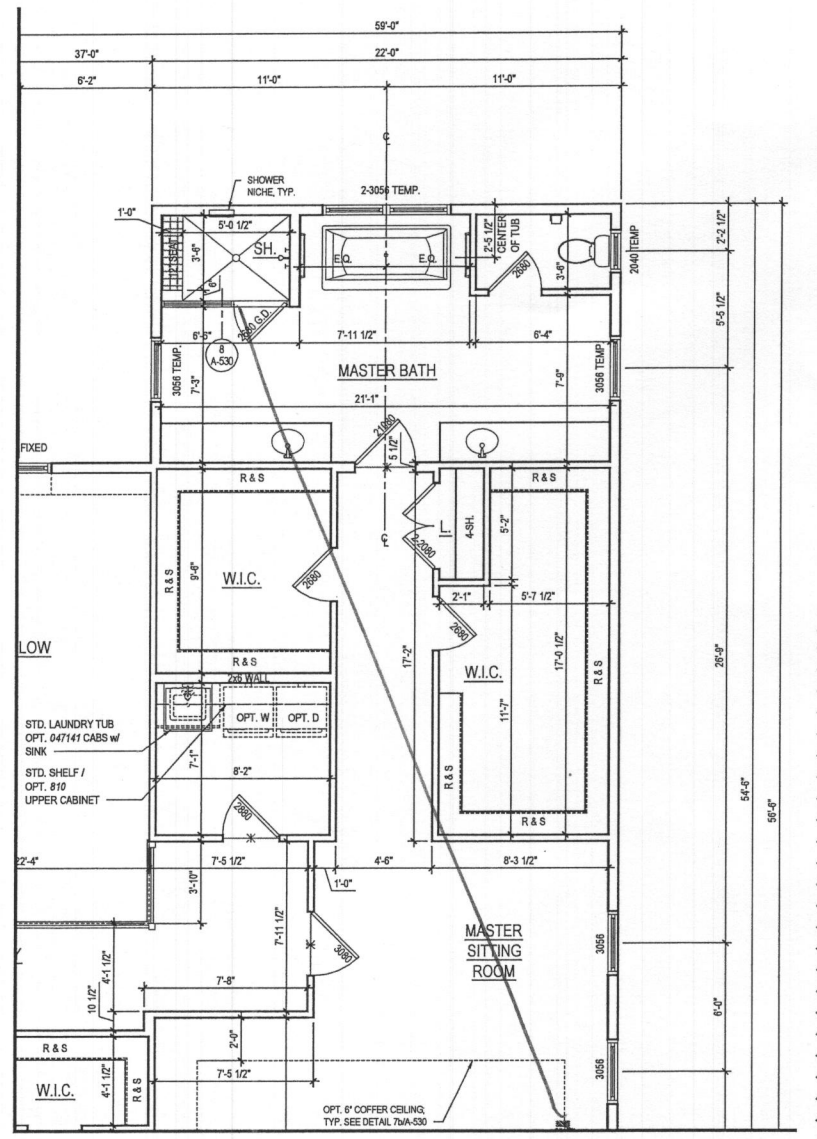

**2 PART. SECOND FLOOR PLAN** w/ OPT. 030 - ADDITIONAL WALK IN CLOSET  
 A-120 SCALE: 1/4"=1'-0"  
 TOLUBA\_A120.DWG

- GENERAL PLAN NOTES**
- A. ALL WOOD STUD PARTITIONS NOT DIMENSIONED ARE TO BE 3 1/2" FOR INTERIOR AND 5 1/2" FOR EXTERIOR WALLS UNLESS OTHERWISE NOTED.
  - B. ALL INTERIOR DIMENSIONS ARE TO FACE OF STUDS.
  - C. ALL EXTERIOR DIMENSIONS ARE TO FACE OF STUDS.
  - D. ALL DIMENSIONS GOVERN OVER SCALE.
  - E. ALL SMOKE DETECTORS ARE TO BE WIRED IN SUCH A MANNER THAT ACTIVATION OF ONE WILL ACTIVATE THEM ALL.
  - F. ENCLOSED ACCESSIBLE SPACE UNDER STAIRS SHALL HAVE WALLS AND SOFFITS PROTECTED ON ENCLOSED SIDE WITH 1/2" GYPSUM BOARD.
  - G. ALL WINDOWS SIZE ARE NOTED IN FEET + INCHES AS MEASURED FROM SASH TO SASH.
  - H. REFER TO ELEVATIONS FOR WINDOW HEAD HEIGHTS.
  - I. ALL DOORS ARE TO BE 6'-8" HIGH UNLESS OTHERWISE NOTED.
  - J. WASHER ALWAYS TO BE ON LEFT SIDE OF DRYER.
  - K. DISHWASHER ALWAYS TO BE ON RIGHT SIDE OF SINK.

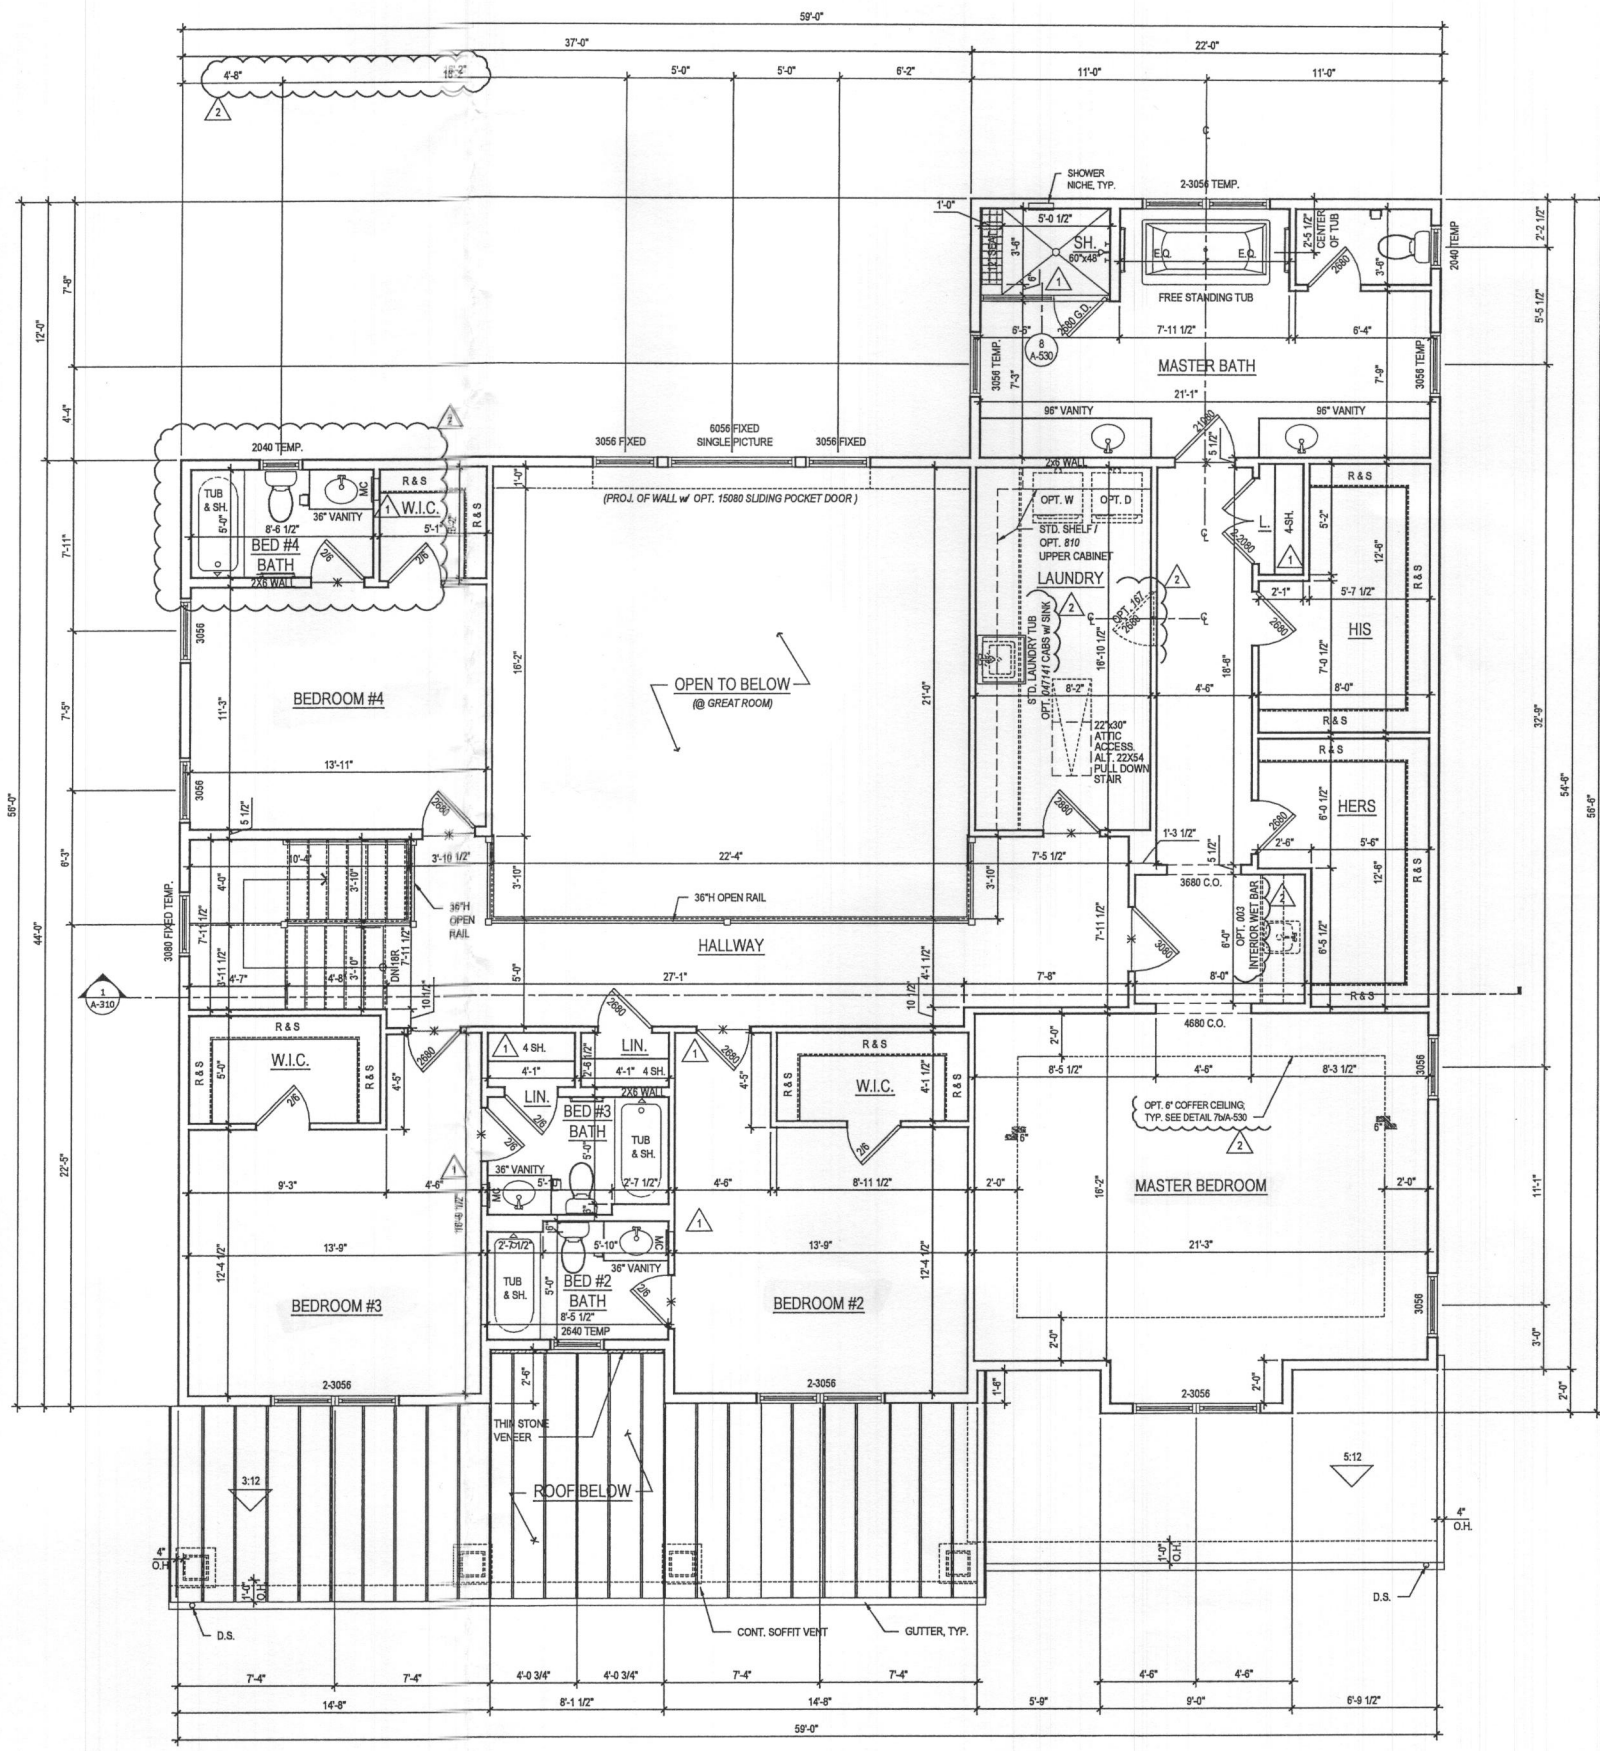

**1 SECOND FLOOR PLAN**  
 A-120 SCALE: 1/4"=1'-0"  
 TOLUBA\_A120.DWG

@ ELEV. 1 - CRAFTSMAN *shown*  
 See additional pages for "Modern Farmhouse" ELV

ARCHITECT:  
  
 8521 Leesburg Pike  
 Suite 700 | Vienna, VA 22182  
 P: 571.830.1800 | F: 571.830.1801  
 www.lessarddesign.com

SEAL & SIGNATURE:

OWNER:  
**TOLL BROTHERS**  
 19775 BELMONT EXECUTIVE PLAZA  
 ASHBURN, VA 20147  
 P: 571.291.8068  
 CONTACT: CHRISTINA LEMLEY  
 clemley@tollbrothers.com

PROJECT NAME:  
**MARYLAND PARKHURST FLOOR PLANS**


SHEET TITLE:

NO.	ISSUE / REVISION	DATE
1	BID SET	05.29.19
2	PERMIT SET	06.19.19
1	MD NEW STANDARDS	09.16.19
2	MR #220241	12.11.20

PROJECT No: TOL081a  
 DRAWN BY: ACHN  
 CHECKED BY: ACHN  
 PLOT DATE: Jan. 20, 2021  
 FILE NAME: TOL081a\_A120.dwg

**A-120**

- GENERAL PLAN NOTES**
- A. ALL WOOD STUD PARTITIONS NOT DIMENSIONED ARE TO BE 3 1/2" FOR INTERIOR AND 5 1/2" FOR EXTERIOR WALLS UNLESS OTHERWISE NOTED.
  - B. ALL INTERIOR DIMENSIONS ARE TO FACE OF STUDS.
  - C. ALL EXTERIOR DIMENSIONS ARE TO FACE OF STUDS.
  - D. ALL DIMENSIONS GOVERN OVER SCALE.
  - E. ALL SMOKE DETECTORS ARE TO BE WIRED IN SUCH A MANNER THAT ACTIVATION OF ONE WILL ACTIVATE THEM ALL.
  - F. ENCLOSED ACCESSIBLE SPACE UNDER STAIRS SHALL HAVE WALLS AND SOFFITS PROTECTED ON ENCLOSED SIDE WITH 1/2" GYPSUM BOARD.
  - G. ALL WINDOWS SIZE ARE NOTED IN FEET + INCHES AS MEASURED FROM SASH TO SASH.
  - H. REFER TO ELEVATIONS FOR WINDOW HEAD HEIGHTS.
  - I. ALL DOORS ARE TO BE 6'-8" HIGH UNLESS OTHERWISE NOTED.
  - J. WASHER ALWAYS TO BE ON LEFT SIDE OF DRYER.
  - K. DISHWASHER ALWAYS TO BE ON RIGHT SIDE OF SINK.

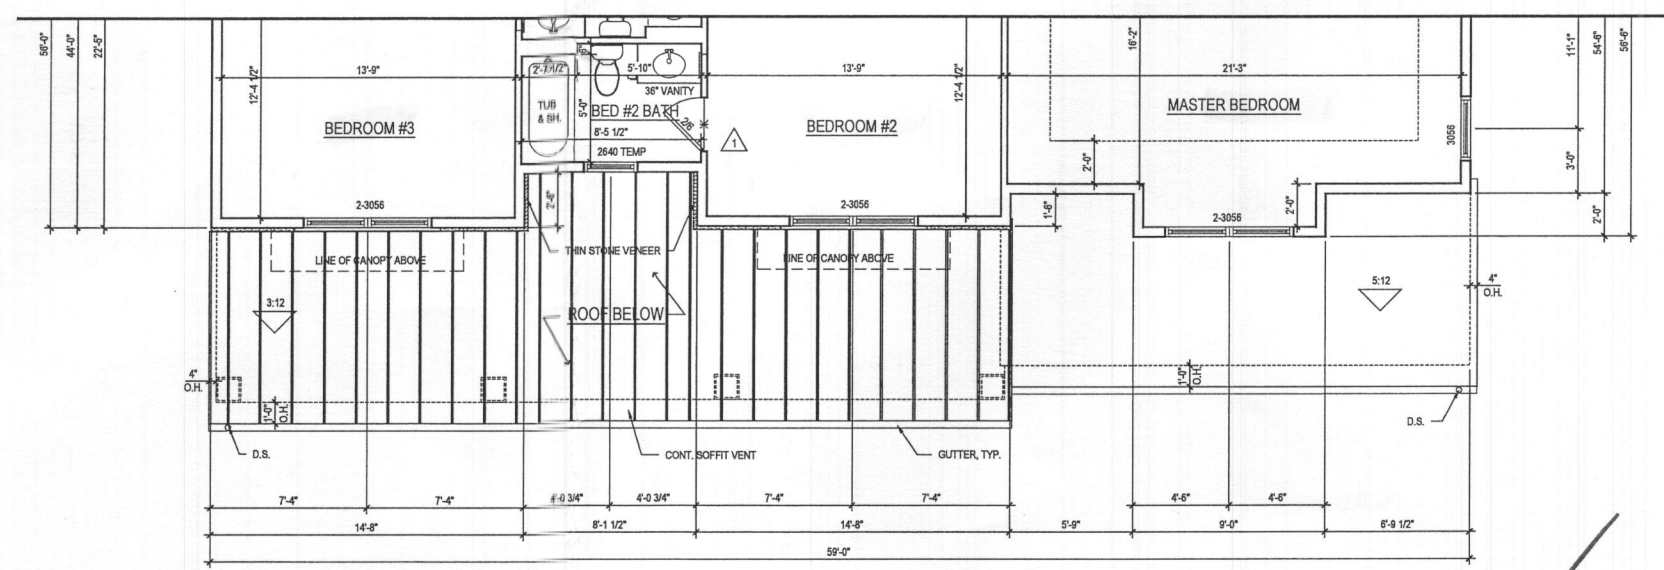

**1 SECOND FLOOR PLAN**  
 SCALE: 1/4"=1'-0"  
 A-141 TOL081A\_A141.DWG

@ ELEV. 2 - MODERN FARMHOUSE

ARCHITECT:

**lessard DESIGN**  
 8521 Leesburg Pike  
 Suite 700 | Vienna, VA 22182  
 P: 571.830.1800 | F: 571.830.1801  
 www.lessarddesign.com

SEAL & SIGNATURE:

OWNER:

**TOLL BROTHERS**  
 19775 BELMONT EXECUTIVE PLAZA  
 ASHBURN, VA 20147  
 P: 571.291.8068  
 CONTACT: CHRISTINA LEHLEY  
 demley@tollbrothers.com

PROJECT NAME: **MARYLAND**

SHEET TITLE: **PARKHURST FLOOR PLANS**

ISSUE / REVISION		
NO.	DESCRIPTION	DATE
BID SET		05.20.19
PERMIT SET		06.19.19
1	MD NEW STANDARDS	09.16.19
2	MR. #220241	12.11.20

PROJECT No: TOL081A  
 DRAWN BY: ACRA  
 CHECKED BY: AS  
 PLOT DATE: Jan. 20, 2021  
 FILE NAME: TOL081A\_A141.dwg

**A-141**