

6/9/82
avoid work
please

approved 6/19/82
Stayed P 31911

PERMIT

SEWAGE DISPOSAL SYSTEM

MARYLAND STATE DEPARTMENT OF HEALTH

A Repair

HOWARD COUNTY

ELLICOTT CITY

INDEX

DISTRICT 5th

05-351103

DATE 4/30/82

Jack Fyock

IS PERMITTED TO INSTALL ALTER

ADDRESS 13775 Triadelphia Road, Glenelg, Md. 21737

PHONE 988-9270

SUBDIVISION _____ ROAD 12412 Hall Shop Road

LOT _____

PROPERTY OWNER Louis Martin

ADDRESS 12412 Hall Shop Road, Fulton, Md. 20759

Phone: 896-9669

SPECIFICATIONS

SEPTIC TANK CAPACITY _____ GALLONS

DRAIN FIELD _____ DEPTH _____ FEET, BOTTOM AREA _____ SQ. FT.

DEEP TRENCH _____ DEPTH _____ FEET, BOTTOM AREA _____ SQ. FT.

SEEPAGE PITS _____ ABSORBENT SIDE-WALL AREA _____ SQ. FT.

INLET PIPE _____ FT. BELOW ORIGINAL GRADE, MAXIMUM DEPTH _____ FT. BELOW ORIGINAL GRADE

EFFECTIVE DEPTH AT _____ FT. BELOW ORIGINAL GRADE.

LOCATE DISPOSAL AREA _____ FT. FROM _____ LOT LINE AND _____ FT. FROM _____ LOT LINE AS SEEN WHEN FACING LOT FROM

REPAIR - Call for an appointment when ground is opened up and Sanitariana will recommend the repair system.

Trench at least 70 ft. long - 10 ft deep - inlet 4 ft with 6 ft of stones

PLANS APPROVED BY Palmer F. Wine

DATE 4/30/82

COVER NO WORK UNTIL INSPECTED AND APPROVED.

NEITHER THE HOWARD COUNTY COUNCIL NOR THE HEALTH DEPARTMENT IS RESPONSIBLE FOR THE SUCCESSFUL OPERATION OF ANY SYSTEM.

NOTE: IF TRENCH IS USED CALL FOR INSPECTION BEFORE PLACING GRAVEL IN TRENCH.

NOTE: NO DRY WELL SHALL EXCEED 15 FOOT IN DIAMETER.

NOTE: ALL PIPE FROM HOUSE TO DISPOSAL AREA MUST BE CAST IRON.

PERMIT VOID AFTER THREE YEARS.


NOTE: INSTALL STAND PIPE ON SEPTIC TANK AND DRY WELL. STAND PIPES MUST BE 6 INCHES IN DIAMETER. CAST IRON, CONCRETE OR TERRAZZO ACCEPTED.

*INSTALLER IS RESPONSIBLE FOR OBTAINING FINAL APPROVAL ON THIS PERMIT.

BOG. PERMIT SIGNED AND RETURNED 7/8/82
Serial # 19705
Benny Propanic

BOG. PERMIT SIGNED AND RETURNED 5/17/85
Serial # 11567-400

PX 31911

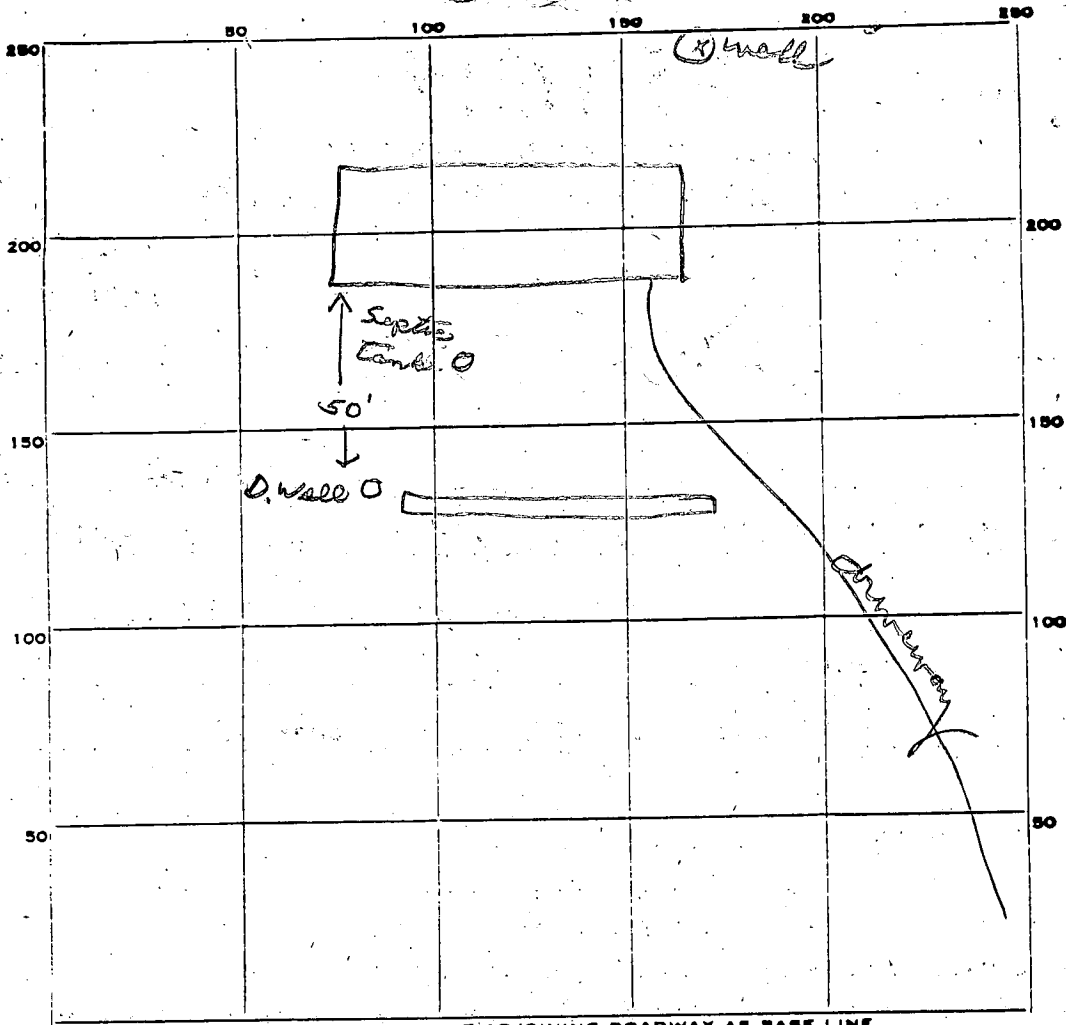

INDICATE NORTH. - NAME ADJOINING ROADWAY AS BASE LINE.

PERMIT CARD _____

SEPTIC TANK, LEVEL _____

CLEANOUTS _____

DISTRIBUTION BOX, LEVEL _____

TILE FIELD, DEPTH 10 FT. TRENCH WIDTH 2 FT.

GRAVEL DEPTH 6' IN. TOTAL LENGTH 80 FT.

NUMBER OF TRENCHES 1 TOTAL BOTTOM AREA 480

SEEPAGE PITS, INSIDE DIAMETER _____ FT. DEPTH BELOW INLET _____ FT.


ABSORBENT AREA 480 SQ. FT.


REMARKS 6/9/82 OK to add stone in trench
6/9/82 OK to cover all work

DATE SYSTEM APPROVED 6/9/82

INSPECTOR Stayer

SEE A59030 A+B
SENT FOR SIGNATURE 2/5/48
ff

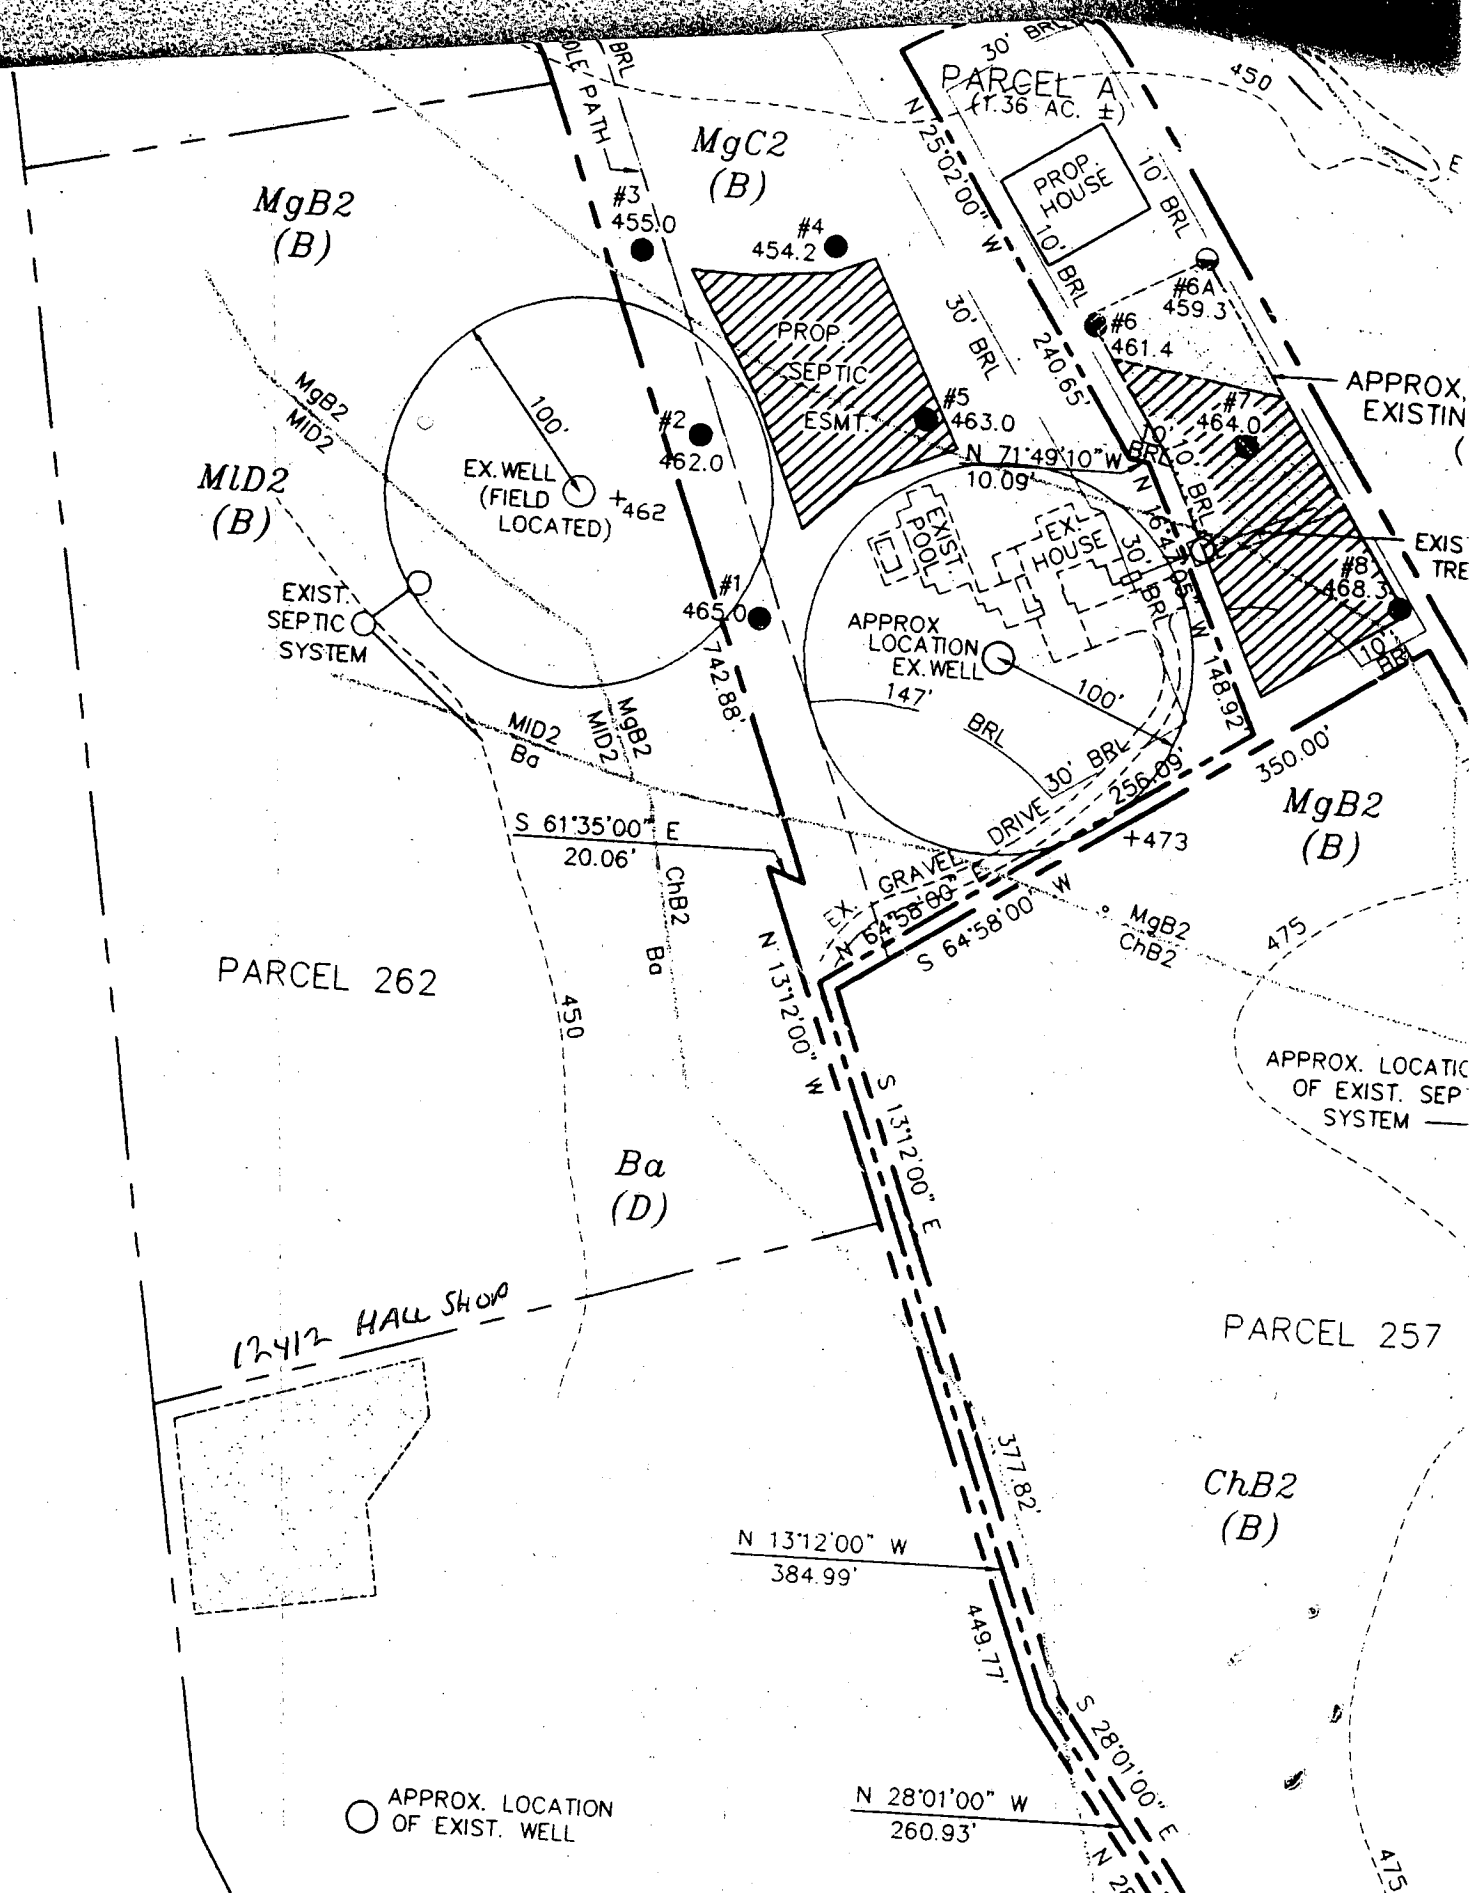

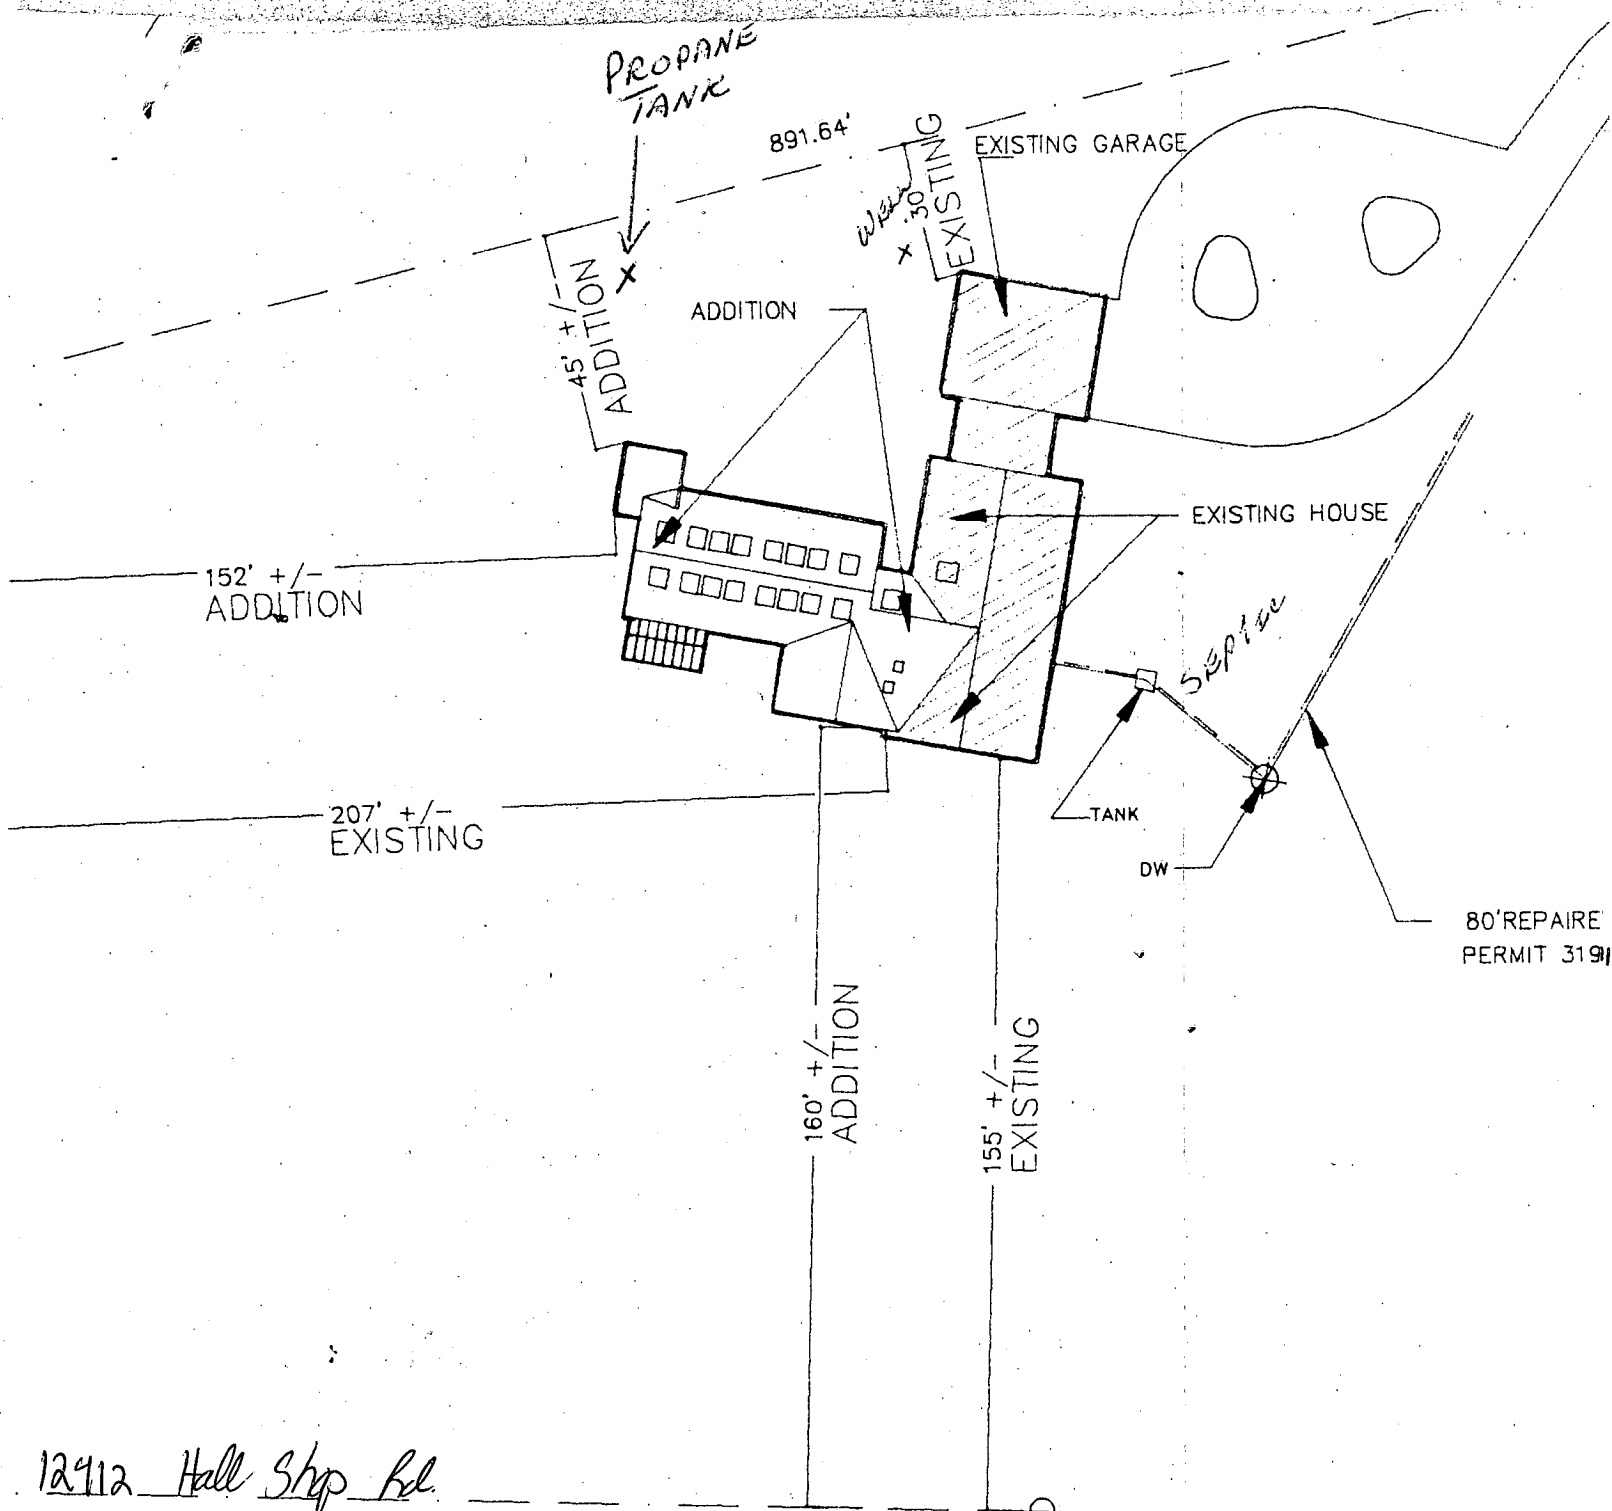

12412 Hall Shop Rd.

OK to sign R. Adges 7/8/88

SITE PLAN

SCALE : 1" = 40'